

**GENERAL INDEX**

FOR DETAILED INDEX OF PLANS SEE SHEET NO. 2

DESCRIPTION	NUMBER OF SHEETS
TITLE SHEET	1
DETAILED INDEX	1
GENERAL NOTES	
TYPICAL SECTIONS	
QUANTITIES	
PLAN AND PROFILES	
SPECIAL DESIGN - BUILDING DRAWINGS	31
BRIDGE DRAWINGS	
SPECIAL DESIGN - BRIDGES	
CROSS-SECTIONS	
<b>TOTAL SHEETS</b>	<b>33</b>

**STATE OF MISSISSIPPI**

**MISSISSIPPI DEPARTMENT OF TRANSPORTATION**

**PLANS OF PROPOSED  
ADDITION TO  
MAINTENANCE AREA HEADQUARTERS  
AT WHITFIELD**


**STATE PROJECT NO. BWO-5031-61(002)**

501502/301000

09-14-04

**RANKIN COUNTY**

FED. ROAD REG. NO.	STATE	PROJECT NO.	SHEET NO.
4	MISS.		1

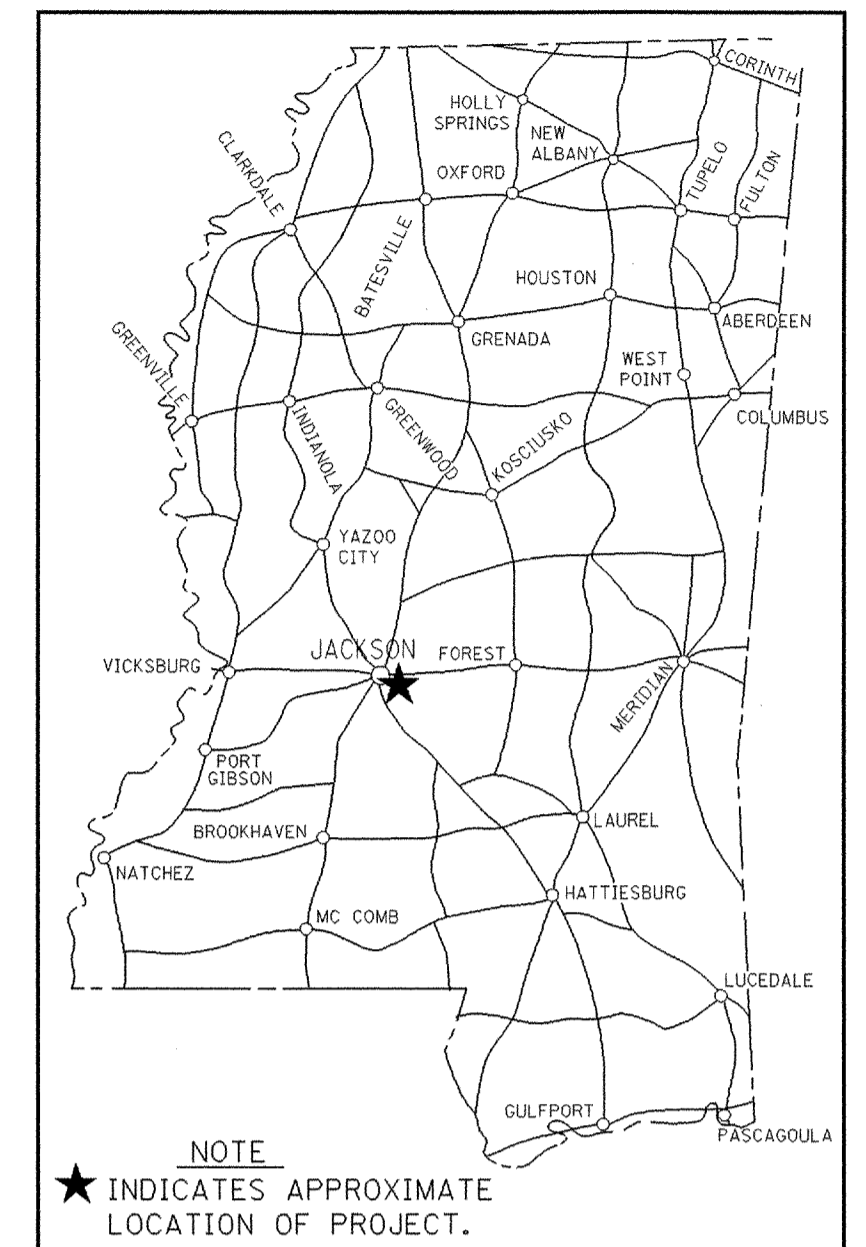

**DESIGN CONTROL**

MPH = V (SPEED DESIGN)

ADT ( ) = : ADT ( ) =

DHV = : D = % T = %

**PERMITS ACQUIRED BY MDOT**

WETLANDS AND WATERS PERMITS (NECESSARY FOR ULTIMATE IMPROVEMENTS ONLY):

	WATERS	WETLANDS
NATIONWIDE #14	N	N
NATIONWIDE (OTHER)*	N	N
GENERAL*	N	N
INDIVIDUAL (404)*	N	N

\* ACQUISITION OF PERMITS FOR TEMPORARY IMPACTS DURING CONSTRUCTION ARE THE RESPONSIBILITY OF THE CONTRACTOR


**STORMWATER PERMIT** N

Y REQUIRED, CNOI SUBMITTED BY MDOT (DISTRIBUTED AREA = 5 ACRES + (NTB 6484))

S REQUIRED, SCNOI TO BE SUBMITTED BY CONTRACTOR (1 TO 4.99 ACRES) (NTB 6483)

N NO STORMWATER PERMIT REQUIRED (<1 ACRE)

APPROVED BY: *[Signature]* DATE: 9-13-04

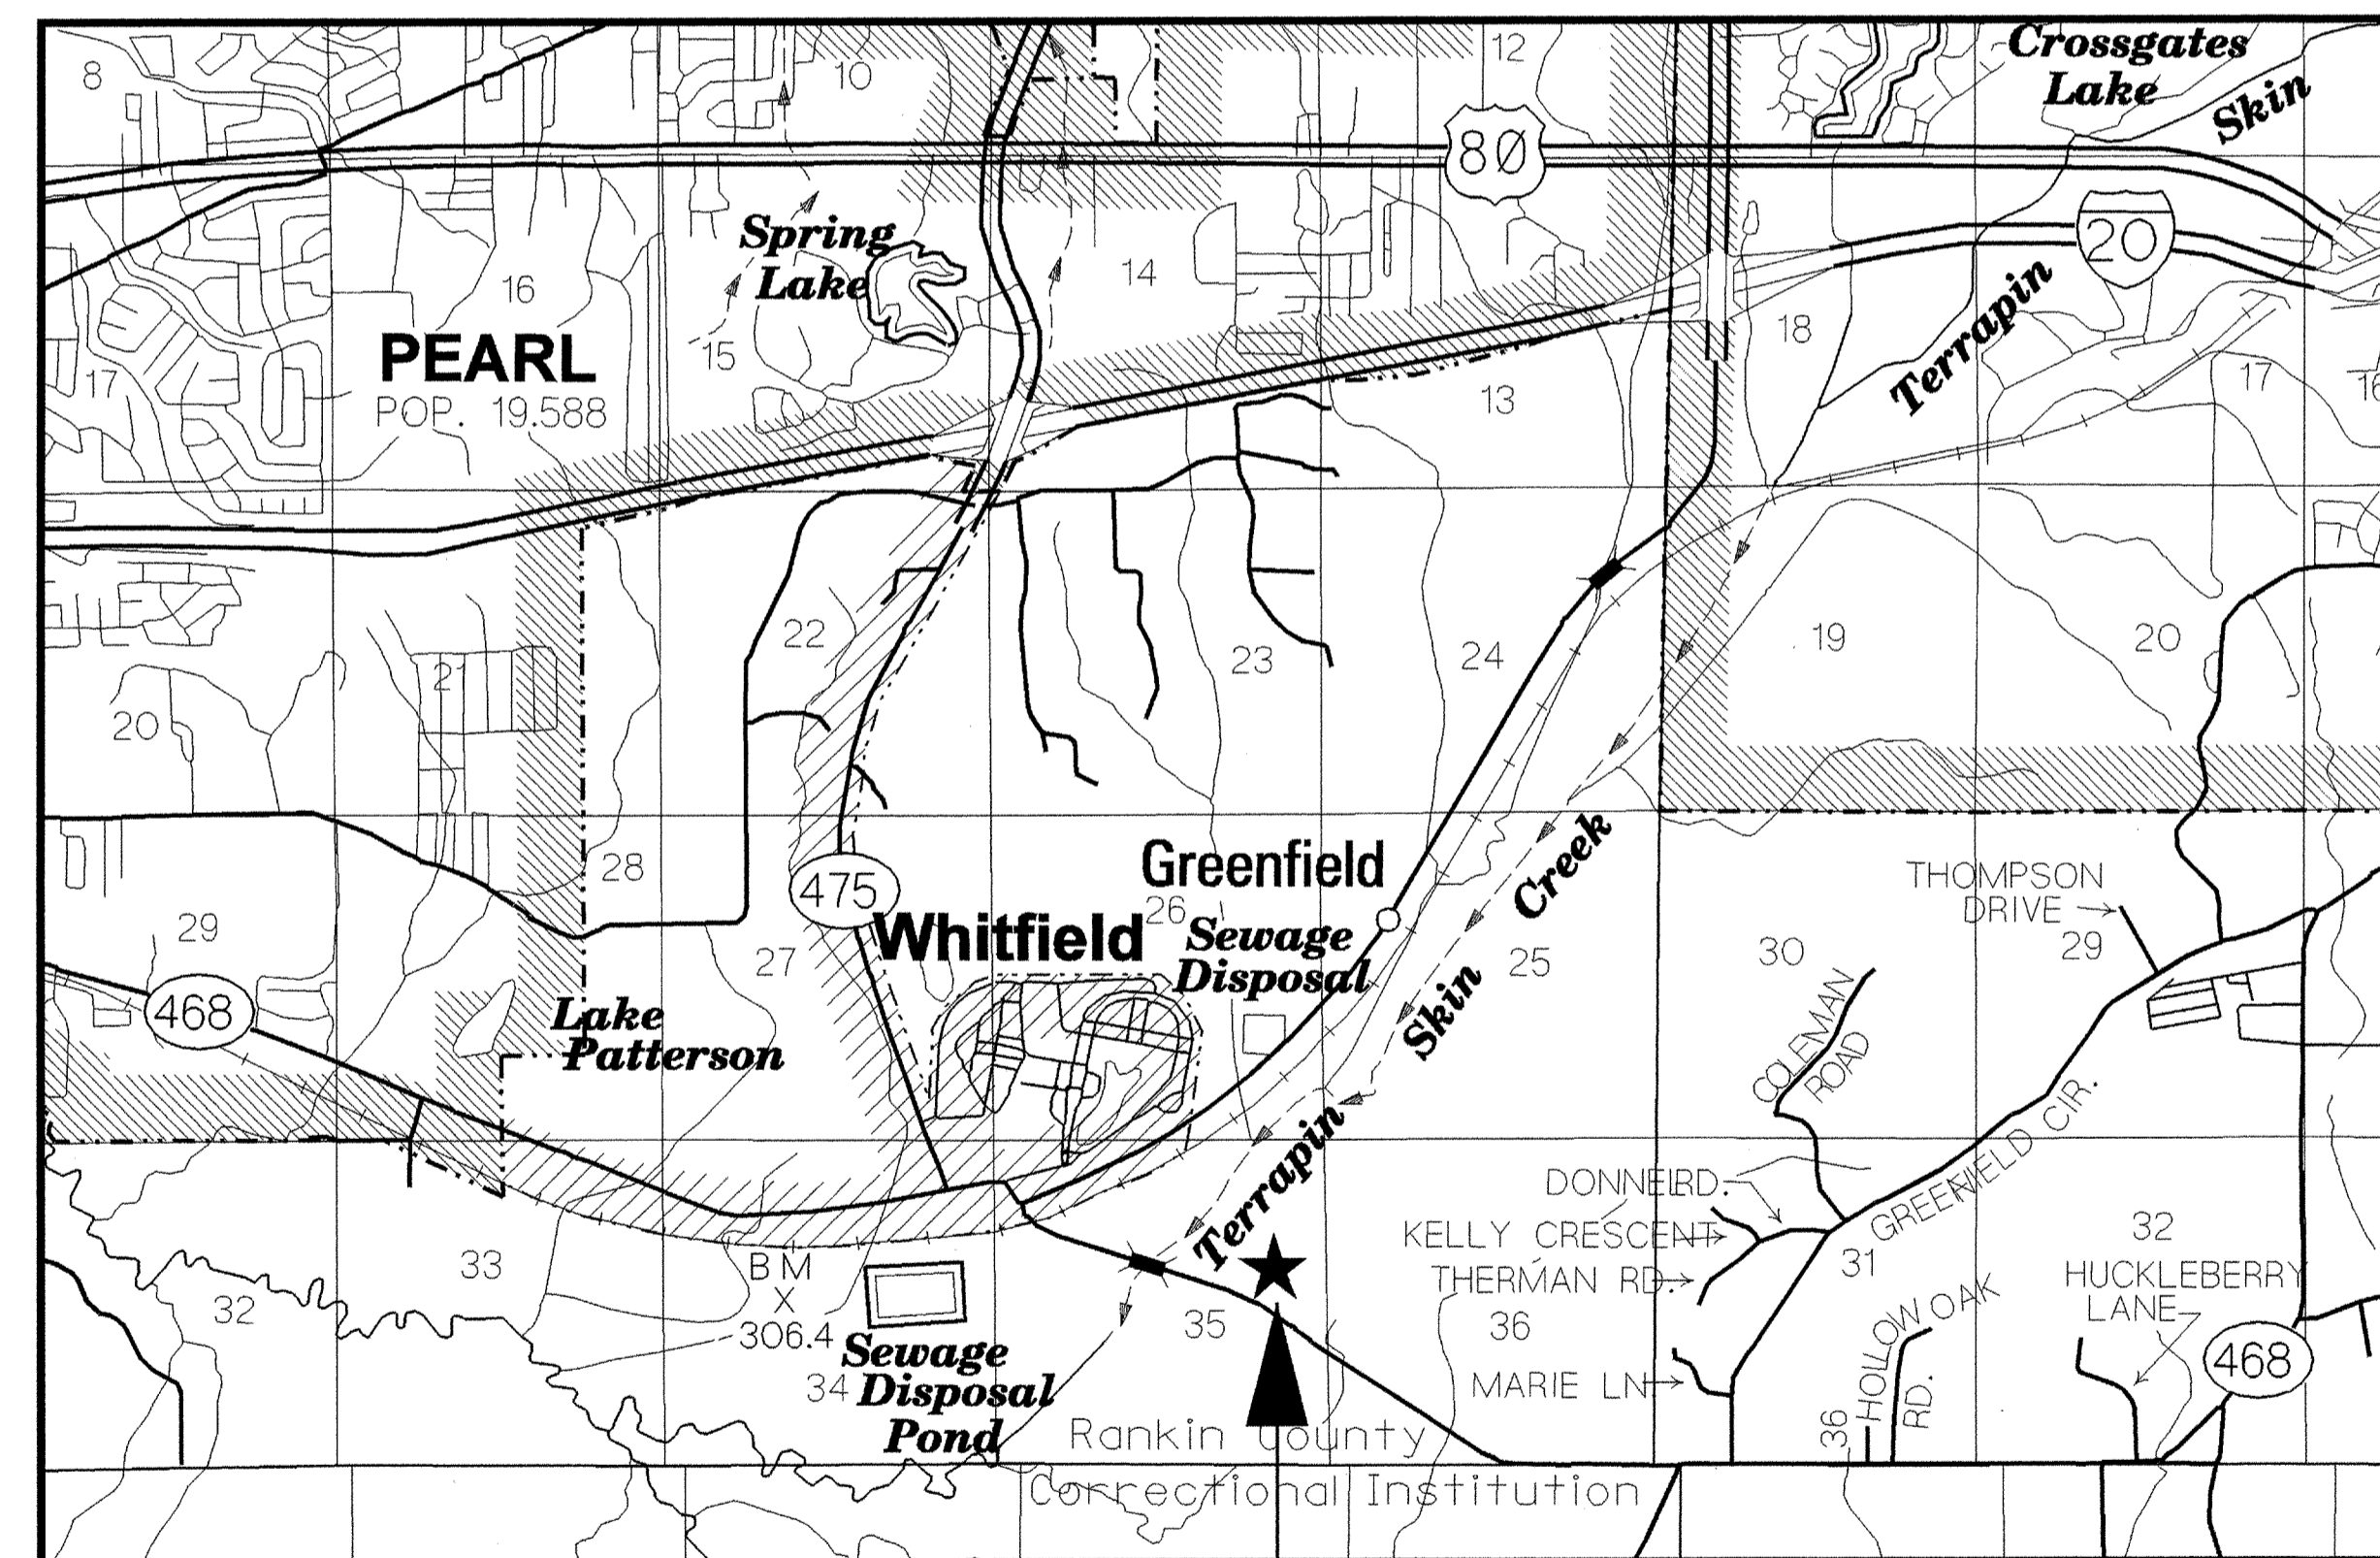

**CONVENTIONAL SYMBOLS**

- COUNTY LINE -----
- TOWN CORPORATION LINE -----
- SECTION LINE -----
- EXISTING ROAD OR TRAVELED WAY -----
- PROPOSED ROAD OR TRAVELED WAY -----
- RAILROAD -----
- SURVEY LINE -----
- BRIDGES -----

**PROJECT SITE  
ON HWY 483**

REVISIONS	DATE	BY	APPROVED:	DATE
			<i>[Signature]</i> CHIEF ENGINEER	9/13/04
			<i>[Signature]</i> EXECUTIVE DIRECTOR	9/13/04
			MISSISSIPPI DEPARTMENT OF TRANSPORTATION	
			APPROVED:	
			DIVISION ADMINISTRATOR	DATE
			FEDERAL HIGHWAY ADMINISTRATION DEPARTMENT OF TRANSPORTATION	

**DESCRIPTION OF SHEET**


**WKG. NO. SH. NO.**

TITLE SHEET	---	1
DETAILED INDEX, ABBREVIATIONS, AND SYMBOL LEGEND	DI-1	2
SITE PLAN	A1.1	3
FLOOR PLAN	A1.2	4
FLOOR FINISH PLAN	A1.3	5
REFLECTED CEILING PLAN	A1.4	6
ROOF FRAMING PLAN	A1.5	7
ROOF PLAN	A1.6	8
NORTH & SOUTH ELEVATIONS	A2.1	9
EAST & WEST ELEVATIONS	A2.2	10
INTERIOR VIEWS	A2.3	11
INTERIOR VIEWS	A2.4	12
WALL SECTION & DETAILS	A3.1	13
WALL SECTIONS	A3.2	14
CABINET SECTIONS	A4.1	15
DOOR & WINDOW DETAILS	A5.1	16
SCHEDULES	A6.1	17
FOUNDATION PLAN & DETAILS	S1.1	18
PLUMBING LEGEND, ABBREVIATIONS, AND GENERAL NOTES	P0.1	19
SITE PLAN - PLUMBING	P1.0	20
FLOOR PLAN - PLUMBING	P2.1	21
PLUMBING SCHEDULES, DETAILS AND PLUMBING RISERS	P3.1	22
HVAC LEGEND, ABBREVIATIONS AND GENERAL NOTES	M0.1	23
FLOOR PLAN - HVAC	M2.1	24
HVAC DETAILS	M3.1	25
HVAC SCHEDULES	M4.1	26
ELECTRICAL LEGEND, ABBREVIATIONS, AND GENERAL NOTES	E0.1	27
SITE PLAN - ELECTRICAL	E1.0	28
FLOOR PLAN - LIGHTING	E2.1	29
FLOOR PLAN - POWER AND COMMUNICATIONS	E2.2	30
ELECTRICAL DETAILS	E3.1	31
ELECTRICAL DETAILS	E3.2	32
ELECTRICAL SCHEDULES AND POWER RISER DIAGRAM	E4.1	33

**ABBREVIATIONS:**

- AFF ..... ABOVE FINISH FLOOR
- BLDG..... BUILDING
- BOTT..... BOTTOM
- CJ ..... CONTROL JOINT
- CLR ..... CLEAR
- CONT..... CONTINUOUS
- DET ..... DETAIL
- DIA ..... DIAMETER
- (E)..... EXISTING
- EA ..... EACH
- EJ ..... EXPANSION JOINT
- ELEC..... ELECTRICAL
- EQL ..... EQUAL
- ETR ..... EXISTING TO REMAIN
- EXTR..... EXTRUDED
- FC ..... FACE OF COLUMN OR CURB
- FD ..... FLOOR DRAIN
- FFL ..... FINISH FLOOR
- FT ..... FEET
- GC ..... GENERAL CONTRACTOR
- MECH..... MECHANICAL
- MET ..... METAL
- NIC ..... NOT IN CONTRACT
- OC ..... ON CENTER
- PL ..... PLATE
- REINF..... REINFORCING
- SCHD..... SCHEDULE
- TYP ..... TYPICAL

**SYMBOL LEGEND:**

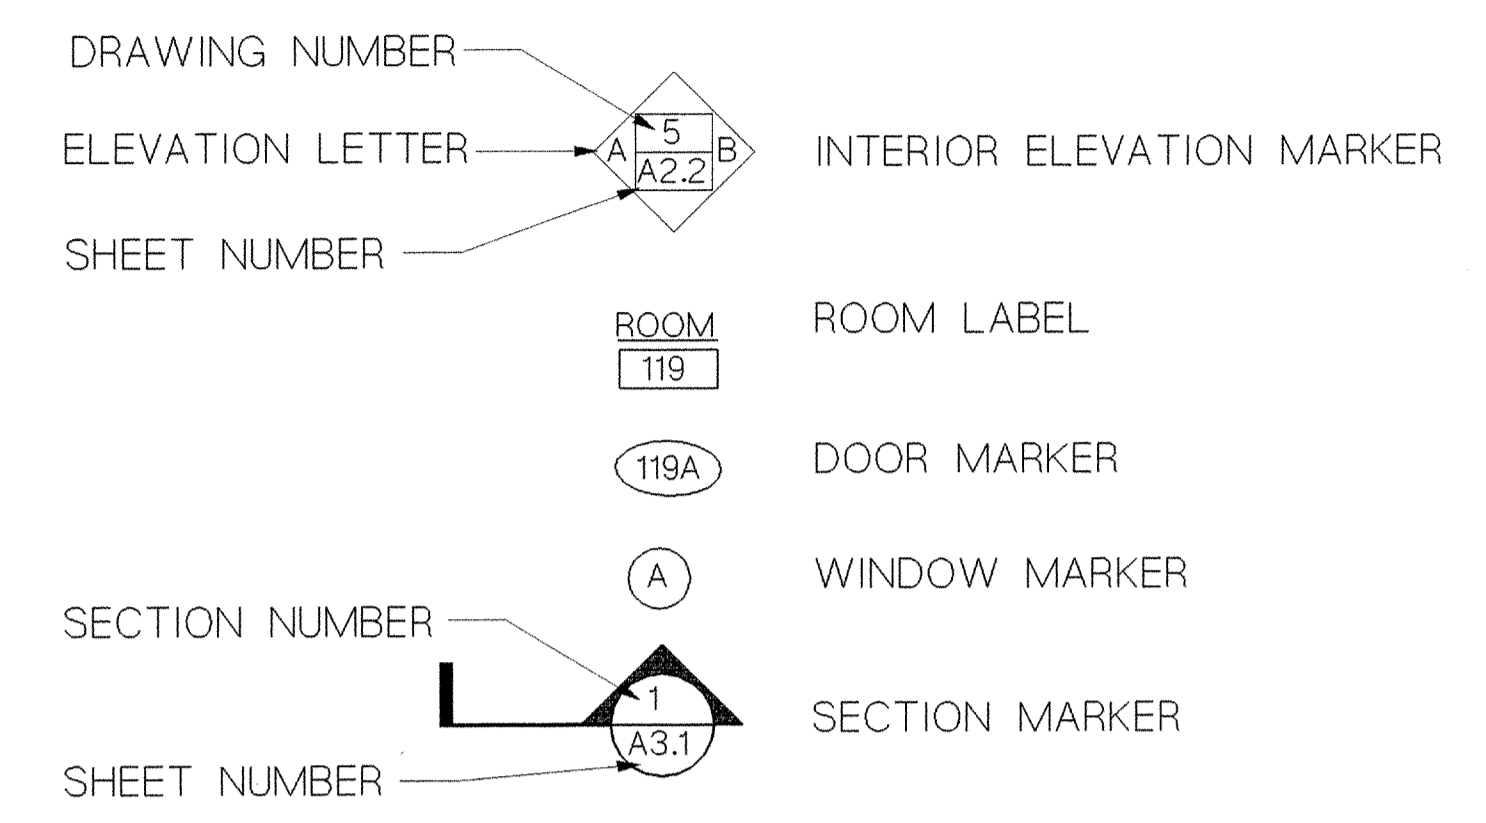

MISSISSIPPI DEPARTMENT OF TRANSPORTATION  
 PLANNING AND DESIGN DIVISION  
 MISSISSIPPI DEPARTMENT OF TRANSPORTATION

PS & E PLANS-DATE 9/14/04		
FMS CON. # 501502 / 301000		
REVISIONS		
DATE	SHEET NO.	BY

BY	MISSISSIPPI DEPARTMENT OF TRANSPORTATION
REVISION	ADDITION TO MAINTENANCE AREA HEADQUARTERS AT WHITFIELD
DATE	WORKING NUMBER
	BWO-5031-61(002) RANKIN COUNTY
	DI-1
	FILENAME: IND.DGN
	SHEET NUMBER
	2
	DESIGN TEAM PARKER CHECKED JWV DATE 9/07/04