

GENERAL INDEX

FOR DETAILED INDEX OF PLANS SEE SHEET NO. 2

DESCRIPTION	NUMBER OF SHEETS
TITLE SHEET	1
DETAILED INDEX	1
GENERAL NOTES	1
TYPICAL SECTIONS	
QUANTITIES	5
PLAN AND PROFILES	11
SPECIAL DESIGN - ROADWAY ITEMS	12
BRIDGE DRAWINGS	
SPECIAL DESIGN - BRIDGES	
CROSS-SECTIONS	
TOTAL SHEETS	31

STATE OF MISSISSIPPI

MISSISSIPPI DEPARTMENT OF TRANSPORTATION

PLAN AND PROFILE OF PROPOSED STATE HIGHWAY

FEDERAL AID PROJECT NO. NH-0020-01(170)


LIGHTING REPAIR ON I-20
FROM MISS. RIVER BRIDGE TO US 61 NORTH
WARREN COUNTY

104230/301000

SCALES

PLAN	1 IN. = 100 FT.
PROFILE	HOR. 1 IN. = 100 FT.
	VERT. 1 IN. = 10 FT.
LAYOUT	1 IN. = FT.

FED. ROAD REG. NO.	STATE	PROJECT NO.	SHEET NO.
4	MISS.	NH-0020-01(170)	1

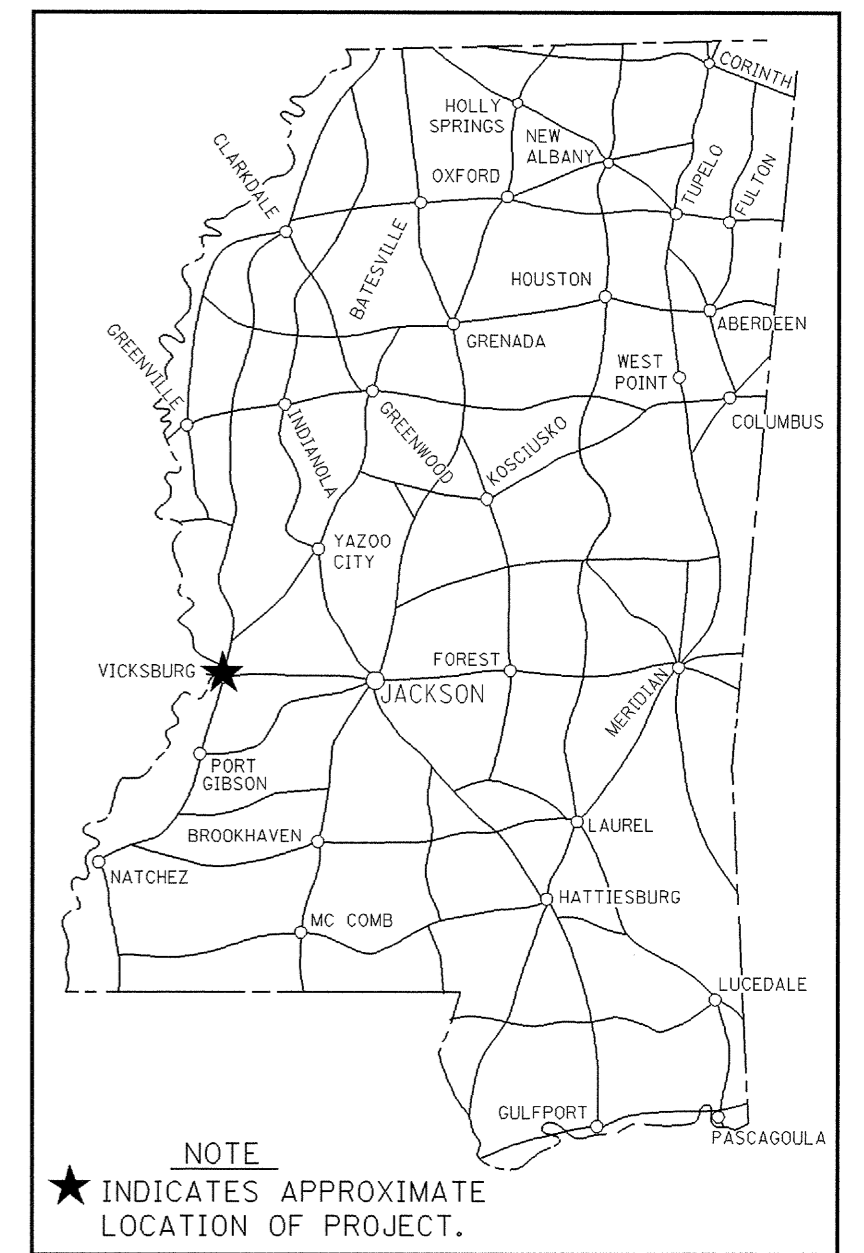


B. O. P. Sta. 19 + 00

E. O. P. Sta. 297 + 00

BRIDGE STRUCTURES REQ'D.
NONE

BOX BRIDGES REQ'D.
NONE

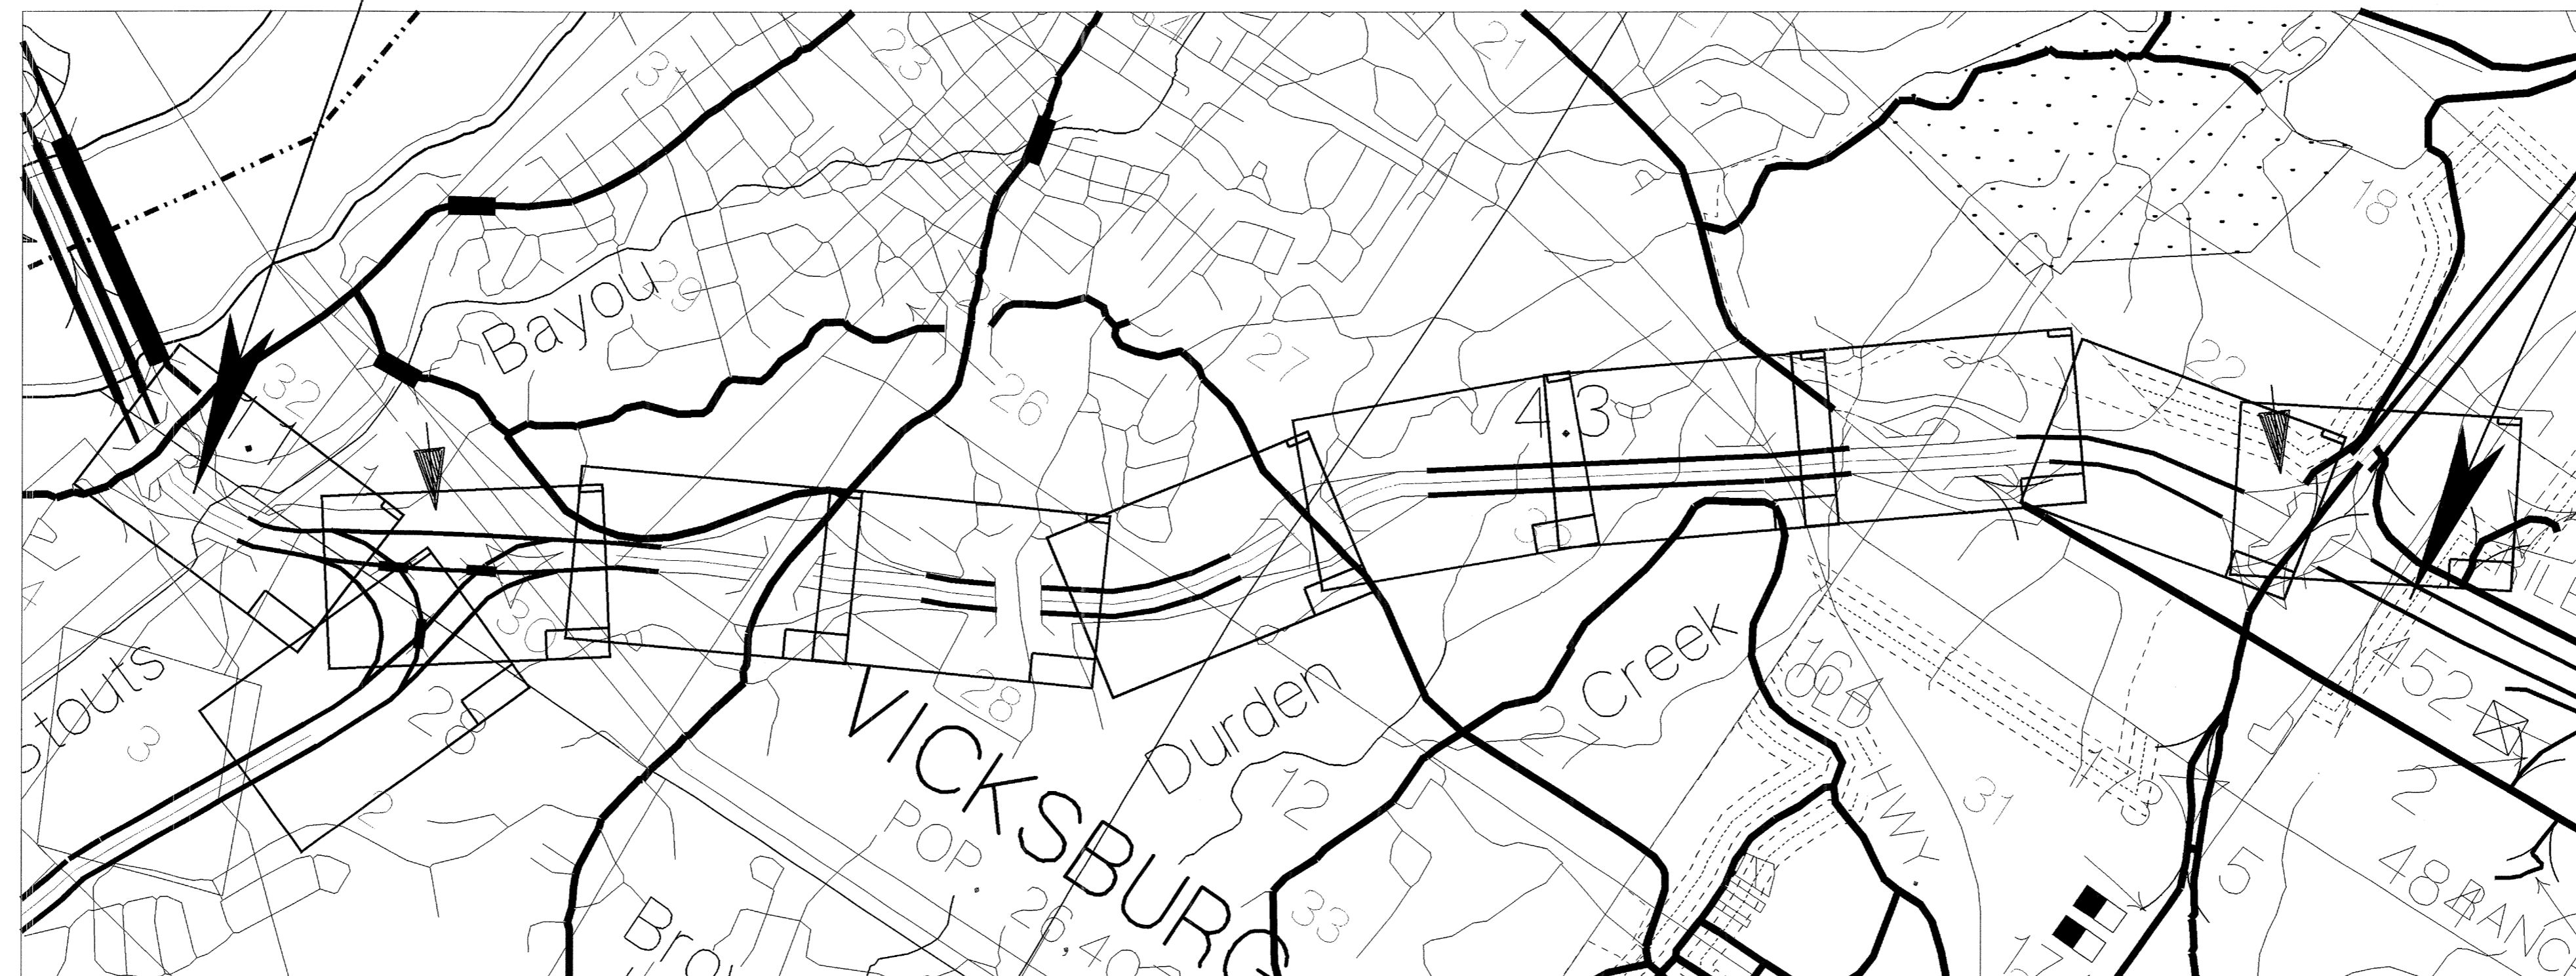

DESIGN CONTROL

MPH = V (SPEED DESIGN)

ADT () = : ADT () =

DHV = : D = % T = %

PERMITS ACQUIRED BY MDOT

WETLANDS AND WATERS PERMITS (NECESSARY FOR ULTIMATE IMPROVEMENTS ONLY):

	WATERS	WETLANDS
NATIONWIDE #14	<input checked="" type="checkbox"/>	<input checked="" type="checkbox"/>
NATIONWIDE (OTHER)*	<input checked="" type="checkbox"/>	<input checked="" type="checkbox"/>
GENERAL*	<input checked="" type="checkbox"/>	<input checked="" type="checkbox"/>
INDIVIDUAL (404)*	<input checked="" type="checkbox"/>	<input checked="" type="checkbox"/>

* ACQUISITION OF PERMITS FOR TEMPORARY IMPACTS DURING CONSTRUCTION ARE THE RESPONSIBILITY OF THE CONTRACTOR

STORMWATER PERMIT

Y REQUIRED CNOI SUBMITTED BY MDOT (DISTRIBUTED AREA = 5 ACRES - INTB 6484)

S REQUIRED SCNOI TO BE SUBMITTED BY CONTRACTOR (1 TO 4.99 ACRES) (INTB 6483)

N NO STORMWATER PERMIT REQUIRED (<1 ACRE)

APPROVED BY: *CEP* DATE: 3/1/04

CONVENTIONAL SYMBOLS

COUNTY LINE	-----
TOWN CORPORATION LINE	-----
SECTION LINE	-----
EXISTING ROAD OR TRAVELED WAY	-----
PROPOSED ROAD OR TRAVELED WAY	-----
RAILROAD	-----
SURVEY LINE	-----
BRIDGES	-----

EQUATIONS

LENGTH DATA

LENGTH OF ROADWAY	28,541 FT.	5.4 MI.
LENGTH OF BRIDGES	FT.	MI.
LENGTH OF PROJECT (NET)	FT.	5.4 MI.
LENGTH OF EXCEPTIONS	FT.	MI.
LENGTH OF PROJECT (GROSS)	FT.	5.4 MI.

EXCEPTIONS

NONE

3-11-2004 1:29 PM TITLE.DGN ROADWAY DESIGN DIVISION MISSISSIPPI DEPARTMENT OF TRANSPORTATION

APPROVED:	<i>Sharon Lee James</i>	3/1/04
CHIEF ENGINEER		DATE
APPROVED:	<i>Ann Brown</i>	03-11-04
EXECUTIVE DIRECTOR		DATE
MISSISSIPPI DEPARTMENT OF TRANSPORTATION		
APPROVED:		
DIVISION ADMINISTRATOR		DATE
FEDERAL HIGHWAY ADMINISTRATION DEPARTMENT OF TRANSPORTATION		

1st O. REV.

STATE	PROJECT NO.
MISS.	NH-0020-01(170)

DESCRIPTION OF SHEET	REVISION DATE	WKG. NO.	SH. NO.
TITLE SHEET (1)		--	1
DETAILED INDEX (1)		DI-1	2
GENERAL NOTES, ABBREVIATIONS & LEGEND (1)		GN-1	3
QUANTITY SHEETS (5)			
SUMMARY OF QUANTITIES		LQ-1	4
SUMMARY OF QUANTITIES		LQ-2	5
RECAPITULATION OF QUANTITIES		LQ-3	6
RECAPITULATION OF QUANTITIES		LQ-4	7
ESTIMATED QUANTITIES FOR TRAFFIC CONTROL SIGNS		TCPQ-1	8
PLAN & PROFILE SHEETS (11)			
LIGHTING LAYOUT - Sta. 19+00 to Sta. 47+00		WK-1	9
LIGHTING LAYOUT - Sta. 47+00 to Sta. 77+00		WK-2	10
LIGHTING LAYOUT - Sta. 887+00 to Sta. 903+00		WK-2a	11
LIGHTING LAYOUT - Sta. 77+00 to Sta. 81+00		WK-3	12
LIGHTING LAYOUT - Sta. 81+00 to Sta. 111+00		WK-4	13
LIGHTING LAYOUT - Sta. 111+00 to Sta. 160+00		WK-5	14
LIGHTING LAYOUT - Sta. 160+00 to Sta. 190+00		WK-6	15
LIGHTING LAYOUT - Sta. 190+00 to Sta. 220+00		WK-7	16
LIGHTING LAYOUT - Sta. 220+00 to Sta. 250+00		WK-8	17
LIGHTING LAYOUT - Sta. 250+00 to Sta. 280+00		WK-9	18
LIGHTING LAYOUT - Sta. 280+00 to Sta. 297+00		WK-10	19
SPECIAL DESIGN SHEETS (8)			
LIGHTING DETAILS		LD-1	20
LIGHTING DETAILS		LD-2	21
LIGHTING DETAILS		LD-3	22
LIGHTING DETAILS		LD-4	23
TEMPORARY LIGHTING & VEGETATION SCHEDULE		TL-1	24
TEMPORARY LIGHTING DETAILS		TL-2	25
CONSTRUCTION SIGNING		CS-1	26
TRAFFIC CONTROL DETAILS DRUM PLACEMENT AND SHOULDER CLOSURE		TCD-1	27
STANDARD DRAWINGS - ROADWAY SHEETS (4)			
TYPICAL TEMPORARY EROSION CONTROL MEASURES (SILT FENCE, HAY BALES & BRUSH BARRIER)		TEC-1	142
TRAFFIC CONTROL PLAN WITH FLAGGER (ONE LANE CLOSURE OF TWO-WAY TRAFFIC)		TCP-1	250
TRAFFIC CONTROL PLAN FOR POSTED SPEED LIMIT LESS THAN 65 MPH (4-LANE: MEDIAN LANE OR OUTSIDE LANE CLOSURE) (WORK DAY ONLY)		TCP-2	251
HIGHWAY SIGN AND BARRICADE DETAILS FOR CONSTRUCTION PROJECTS		TCP-10	259
TOTAL SHEETS			31

PLAN
ROADWAY DESIGN DIVISION, C.A.D.D. SECTION
MISSISSIPPI DEPARTMENT OF TRANSPORTATION

1/3

PS & E PLANS-DATE: 3/17/2004		
FMS CON. # 104230/301000		
REVISIONS		
DATE	SHEET NO.	BY
4/1/04	3	JES
6/3/04	3,4,5,19,23	JES
10/20/04	4	JES

SANSING

MISSISSIPPI DEPARTMENT OF TRANSPORTATION	
DETAILED INDEX	
PROJECT NO. NH-0020-01(170)	
COUNTY : WARREN	
DATE	WORKING NUMBER
DESIGN TEAM	DI-1
CHECKED	SHEET NUMBER
DATE	2

FILENAME: Detailed Index.dgn

DESIGN TEAM _____ CHECKED _____ DATE _____