

FED. ROAD REG. NO.	STATE	PROJECT NO.	SHEET NO.
4	MISS.		1

GENERAL INDEX

FOR DETAILED INDEX OF PLANS SEE SHEET NO. 2

DESCRIPTION	NUMBER OF SHEETS
TITLE SHEET	1
DETAILED INDEX	1
GENERAL NOTES	
TYPICAL SECTIONS	
QUANTITIES	
PLAN AND PROFILES	
SPECIAL DESIGN - BUILDINGS	32
BRIDGE DRAWINGS	
SPECIAL DESIGN - BRIDGES	
CROSS-SECTIONS	
TOTAL SHEETS	34

STATE OF MISSISSIPPI



MISSISSIPPI DEPARTMENT OF TRANSPORTATION

PLANS OF PROPOSED SLOPED ROOF AND MECHANICAL ALTS. FOR DISTRICT OFFICE BUILDING STATE PROJECT NO. BWO-2001-54(008)

07-5-06

501635/301000

PANOLA COUNTY

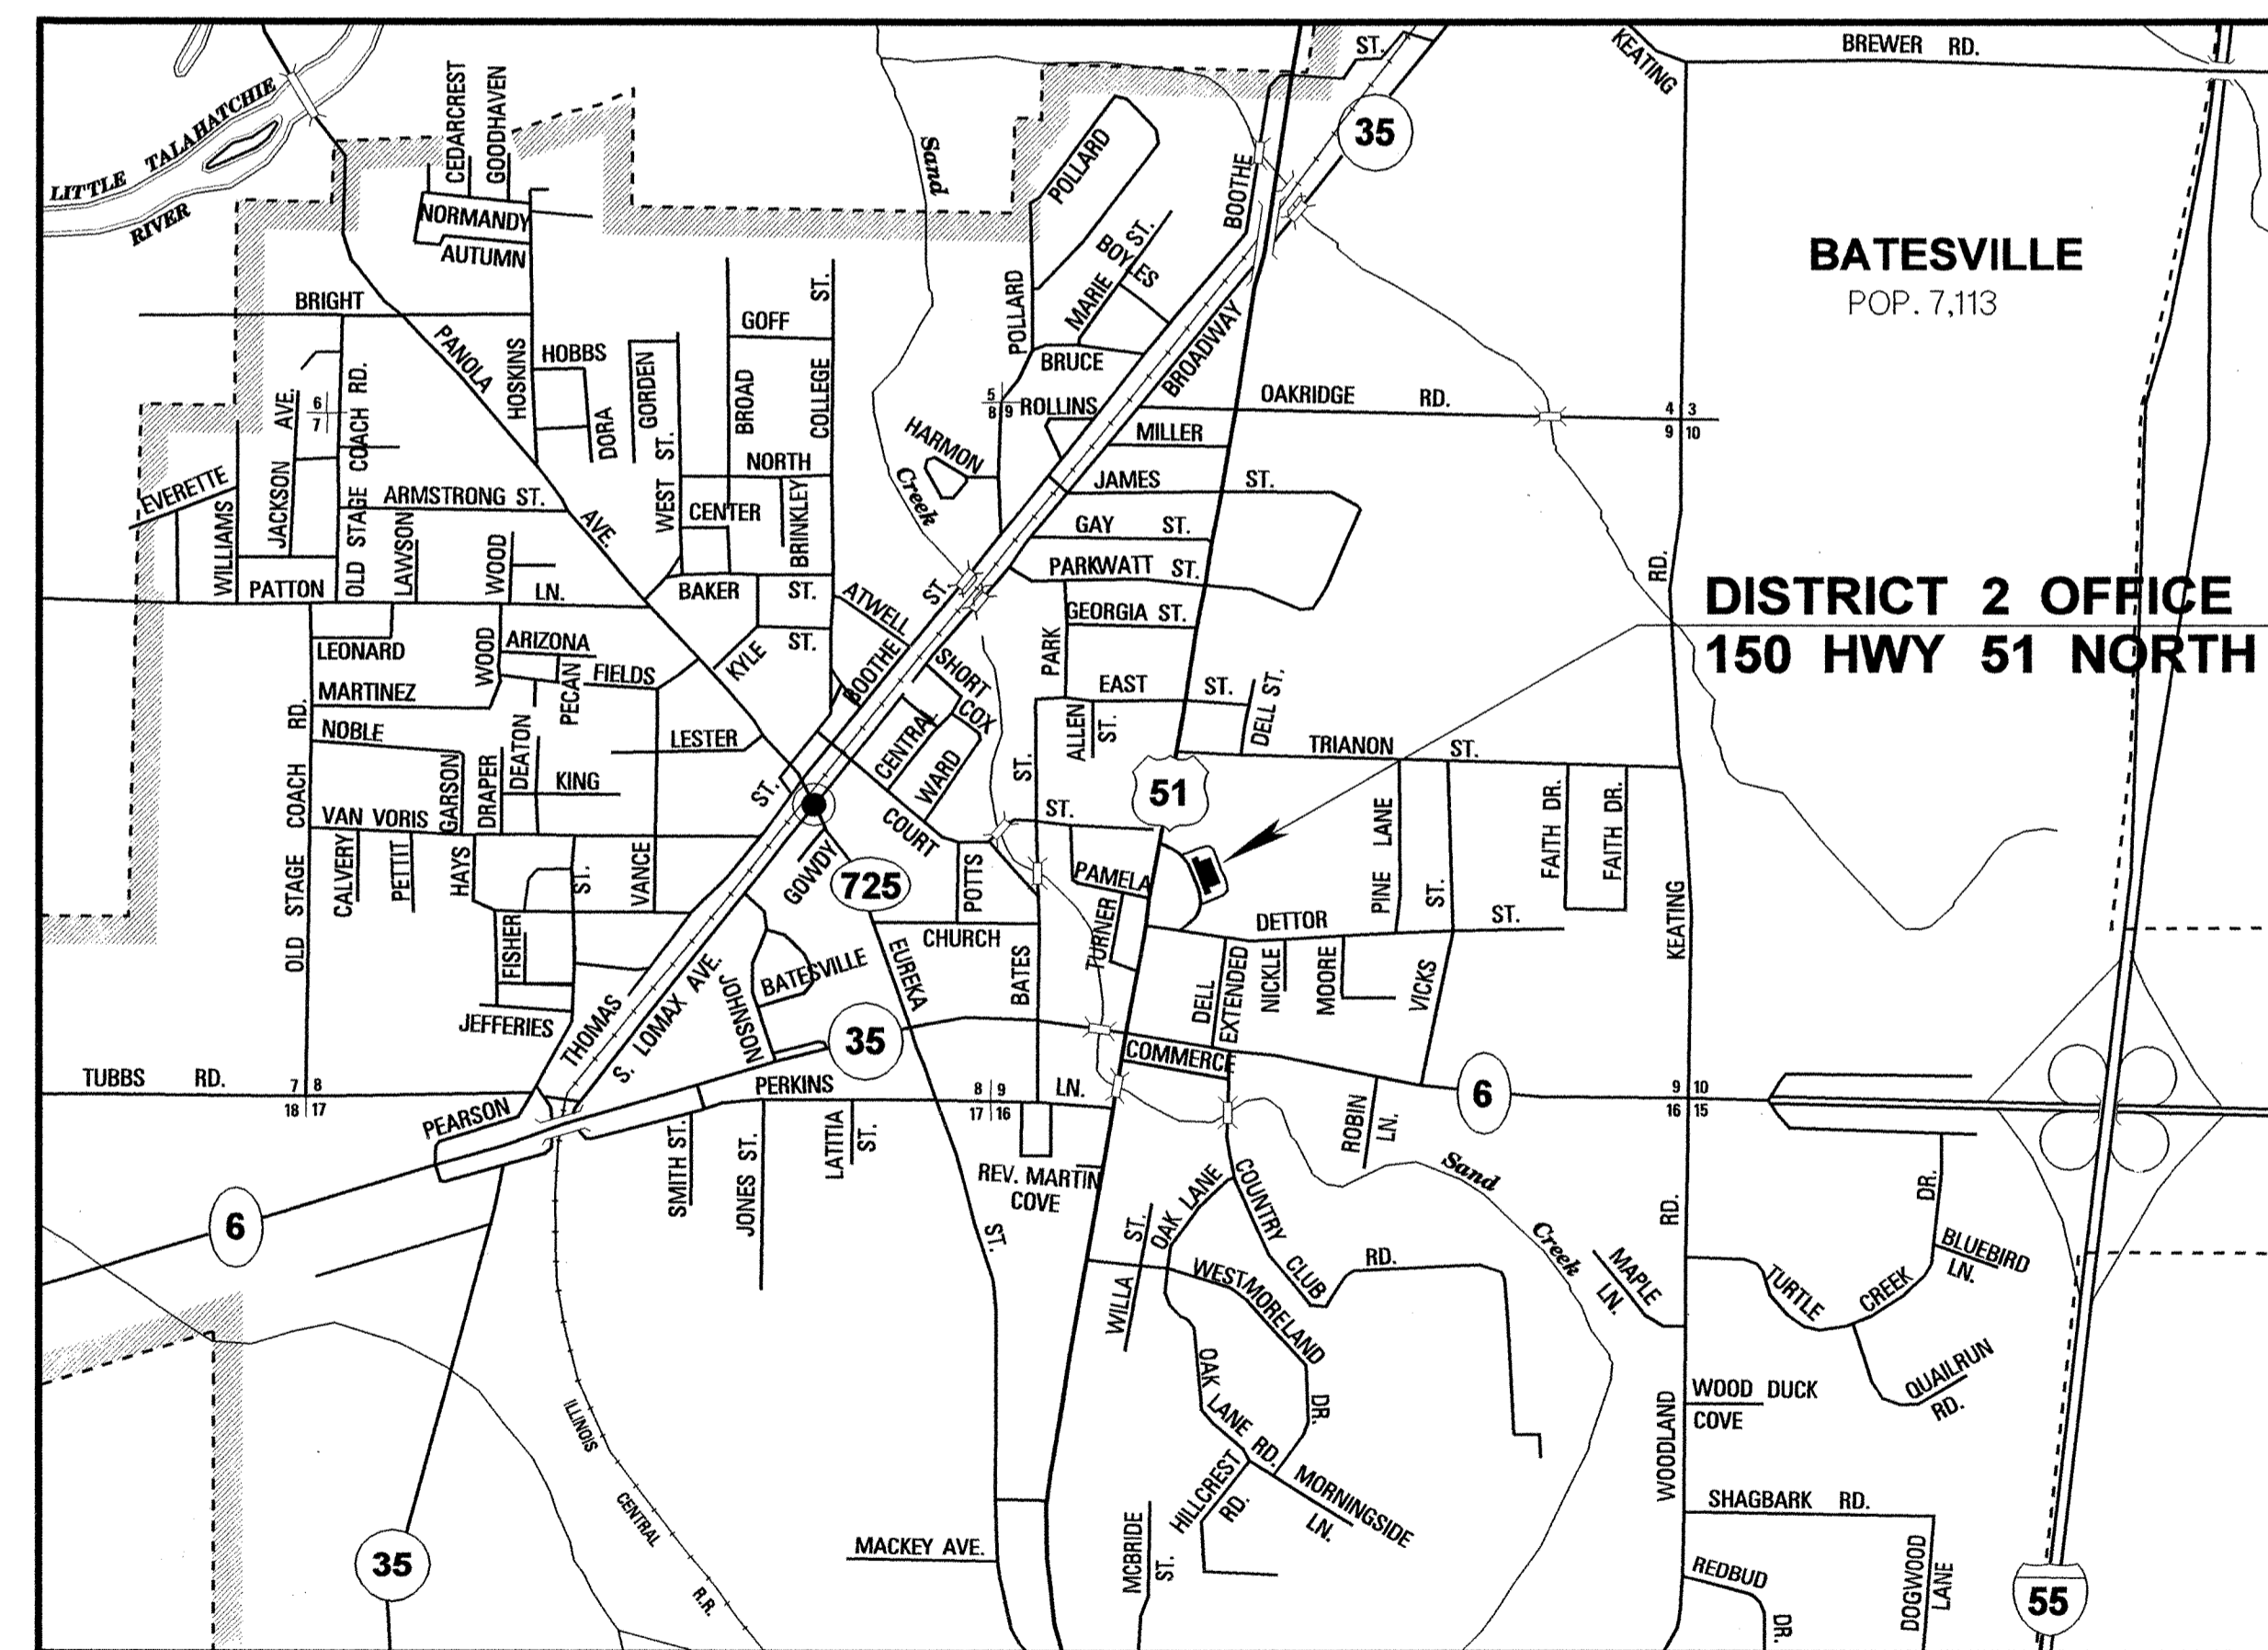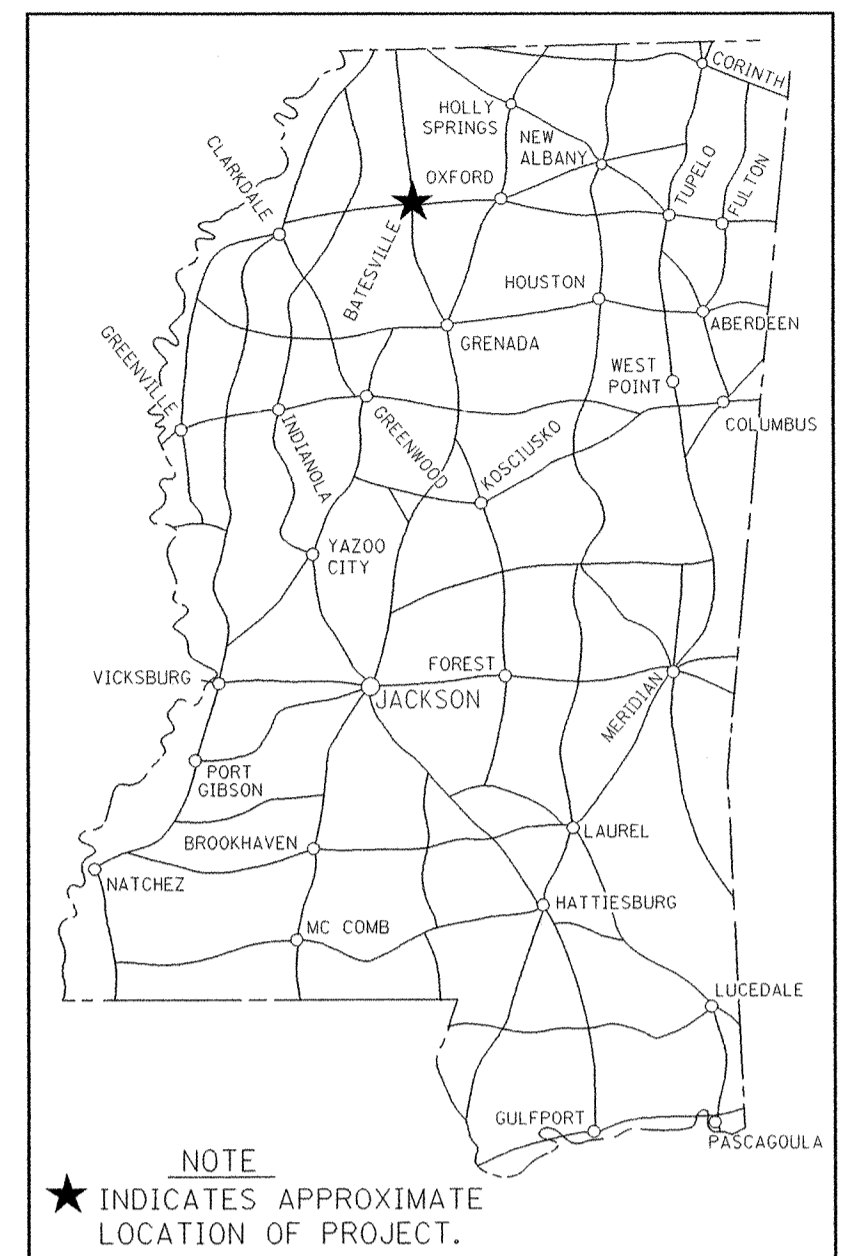

DESIGN CONTROL

MPH = V (SPEED DESIGN)

ADT () = : ADT () =

DHV = : D = % T = %

PERMITS ACQUIRED BY MDOT

WETLANDS AND WATERS PERMITS (NECESSARY FOR ULTIMATE IMPROVEMENTS ONLY):

	WATERS	WETLANDS
NATIONWIDE #14	<input checked="" type="checkbox"/>	<input checked="" type="checkbox"/>
NATIONWIDE (OTHER)*	<input checked="" type="checkbox"/>	<input checked="" type="checkbox"/>
GENERAL*	<input checked="" type="checkbox"/>	<input checked="" type="checkbox"/>
INDIVIDUAL (404)*	<input checked="" type="checkbox"/>	<input checked="" type="checkbox"/>

* ACQUISITION OF PERMITS FOR TEMPORARY IMPACTS DURING CONSTRUCTION ARE THE RESPONSIBILITY OF THE CONTRACTOR

STORMWATER PERMIT

Y REQUIRED, CNOI SUBMITTED BY MDOT (DISTRIBUTED AREA = 5 ACRES + NHTB 6484)

S REQUIRED, SCNOI TO BE SUBMITTED BY CONTRACTOR (1 TO 4.99 ACRES/NHTB 6483)

N NO STORMWATER PERMIT REQUIRED (<1 ACRE)

APPROVED BY: *GU* DATE: 7-5-06

CONVENTIONAL SYMBOLS

- COUNTY LINE -----
- TOWN CORPORATION LINE -----
- SECTION LINE -----
- INTERSTATE OR DIVIDED HIGHWAY -----
- OTHER HIGHWAY OR CITY STREET -----
- RAILROAD -----
- SURVEY LINE -----
- BRIDGES -----

APPROVED BY:	<i>Larry Lee James</i>	DATE: 6-30-06
CHIEF ENGINEER		
APPROVED BY:	<i>Larry Lee James</i>	DATE: 6-30-06
EXECUTIVE DIRECTOR		
MISSISSIPPI DEPARTMENT OF TRANSPORTATION		
APPROVED:		
DIVISION ADMINISTRATOR		DATE
FEDERAL HIGHWAY ADMINISTRATION DEPARTMENT OF TRANSPORTATION		


1st O. REV.

STATE	PROJECT NO.
MISS.	BWO-2001-54(008)



DESCRIPTION OF SHEET

WKG. NO. SH. NO.

TITLE SHEET	—	1
SITE PLAN AND DETAILED INDEX	A1.1	2
FIRST AND SECOND FLOOR PLANS	A1.2	3
FIRST FLOOR AND SECOND FLOOR REFLECTED CEILING PLANS	A1.3	4
EXISTING / DEMO PLAN AND ROOF PLAN	A1.4	5
ELEVATIONS	A2.1	6
SECTIONS	A3.1	7
SCHEDULES	A6.1	8
HVAC LEGEND, ABBREVIATIONS, GENERAL NOTES, TAG SYMBOL LEGEND AND INDEX OF DRAWINGS	M0.1	9
BASEMENT FLOOR PLAN - DEMOLITION, FIRST FLOOR PLAN - DEMOLITION	M1.1	10
SECOND FLOOR PLAN - DEMOLITION	M1.2	11
ROOF PLAN - DEMOLITION	M1.3	12
BASEMENT FLOOR PLAN - HVAC, FIRST FLOOR PLAN - HVAC / RETURN AIR OPENING SCHEDULE	M2.1	13
SECOND FLOOR PLAN - HVAC	M2.2	14
ATTIC FLOOR PLAN - PLUMBING, ATTIC FLOOR PLAN - HVAC	M2.3	15
BUILDING SECTION - HVAC	M3.1	16
HVAC DETAILS	M4.1	17
HVAC DETAILS / WATER HEATER DETAIL	M4.2	18
HVAC SCHEDULES	M5.1	19
HVAC SCHEDULES	M5.2	20
ELECTRICAL LEGEND, ABBREVIATIONS AND GENERAL NOTES	E0.1	21
FIRST FLOOR PLAN - ELECTRICAL DEMOLITION	E1.1	22
SECOND FLOOR PLAN - ELECTRICAL DEMOLITION	E1.2	23
ROOF PLAN - ELECTRICAL DEMOLITION	E1.3	24
FIRST FLOOR PLAN - LIGHTING	E2.1	25
SECOND FLOOR PLAN - LIGHTING	E2.2	26
BASEMENT FLOOR PLAN - HVAC ELECTRICAL CONNECTIONS, FIRST FLOOR PLAN - HVAC ELECTRICAL CONNECTIONS	E2.3	27
ATTIC FLOOR PLAN - HVAC ELECTRICAL CONNECTIONS	E2.4	28
ATTIC FLOOR PLAN - LIGHTING / POWER	E2.5	29
SECOND FLOOR PLAN - NEW PANEL "P2"	E2.6	30
SINGLE LINE DIAGRAM	E3.1	31
ELECTRICAL DETAILS	E3.2	32
ELECTRICAL SCHEDULES	E4.1	33
ELECTRICAL SCHEDULES	E4.2	34

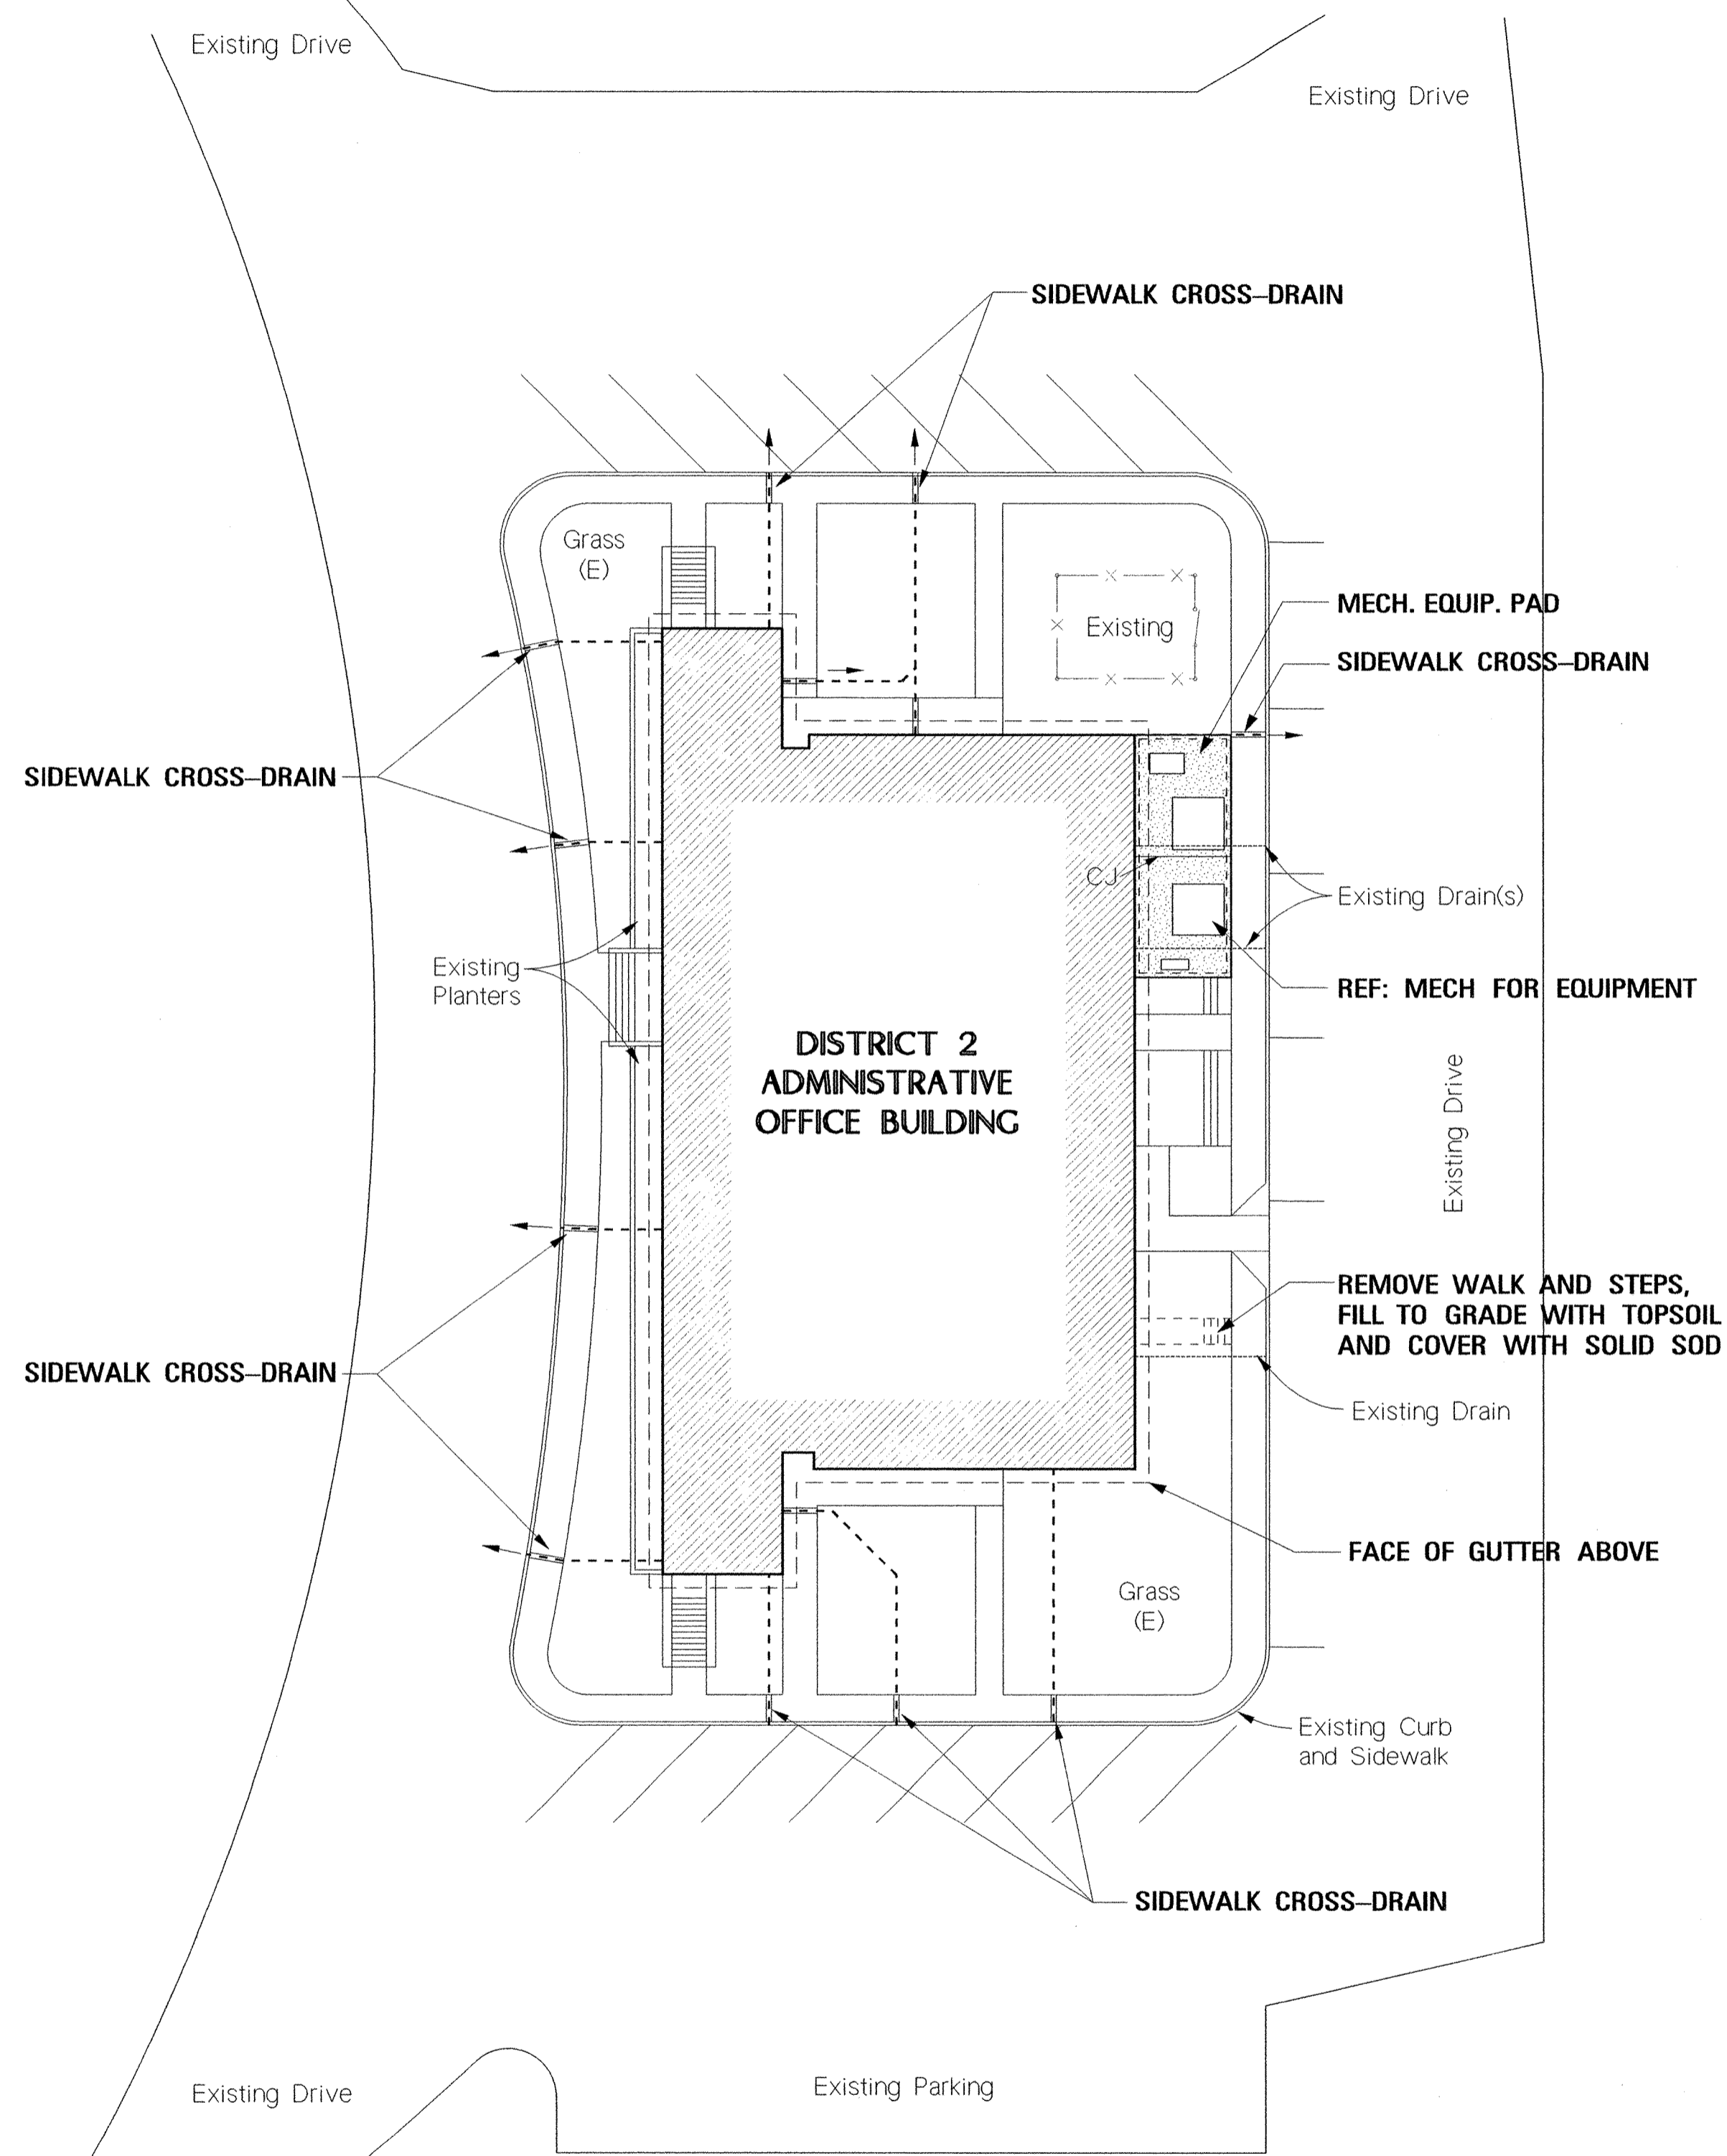

1 SITE PLAN
SCALE: 1" = 20'

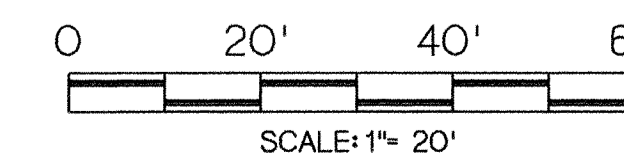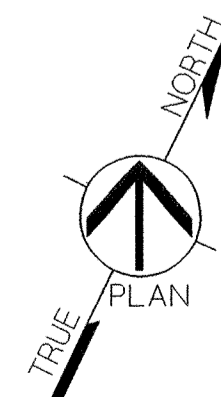

PS & E PLANS-DATE: 07-05-06		
FMS CON. # 501635 / 301000		
REVISIONS		
DATE	SHEET NO.	BY
12/04/06	3, 4, 8 & 13, 14, 15	LGP/SDS
12/04/06	22-24, 26-28, 30, 31, 34	ABK

MISSISSIPPI DEPARTMENT OF TRANSPORTATION SLOPED ROOF & MECHANICAL ALTS. FOR DISTRICT OFFICE BUILDING		ASU
SITE PLAN AND DETAILED INDEX		
WORKING NUMBER	A1.1	
FILENAME:	A11PSIT.DGN	
DESIGN TEAM:	PARKER	CHECKED: JMW DATE: 7/05/06
SHEET NUMBER	2	

5/30/2006 1:38 PM A11PSIT.DGN MISSISSIPPI DEPARTMENT OF TRANSPORTATION ROADWAY DESIGN DIVISION