

FED. ROAD REG. NO.	STATE	PROJECT NO.	SHEET NO.
4	MISS.		1

GENERAL INDEX

FOR DETAILED INDEX OF PLANS SEE SHEET NO. 2

DESCRIPTION	NUMBER OF SHEETS
TITLE SHEET	1
DETAILED INDEX	1
GENERAL NOTES	
TYPICAL SECTIONS	
QUANTITIES	
PLAN AND PROFILES	
SPECIAL DESIGN - BUILDING ITEMS	34
BRIDGE DRAWINGS	
SPECIAL DESIGN - BRIDGES	
CROSS-SECTIONS	
TOTAL SHEETS	36


STATE OF MISSISSIPPI
MISSISSIPPI DEPARTMENT OF TRANSPORTATION

PLANS OF PROPOSED
PROJECT OFFICE BUILDING AT NEW ALBANY
STATE PROJECT NO. BWO-1138-73(001)


501398/301000

01-8-07

UNION COUNTY

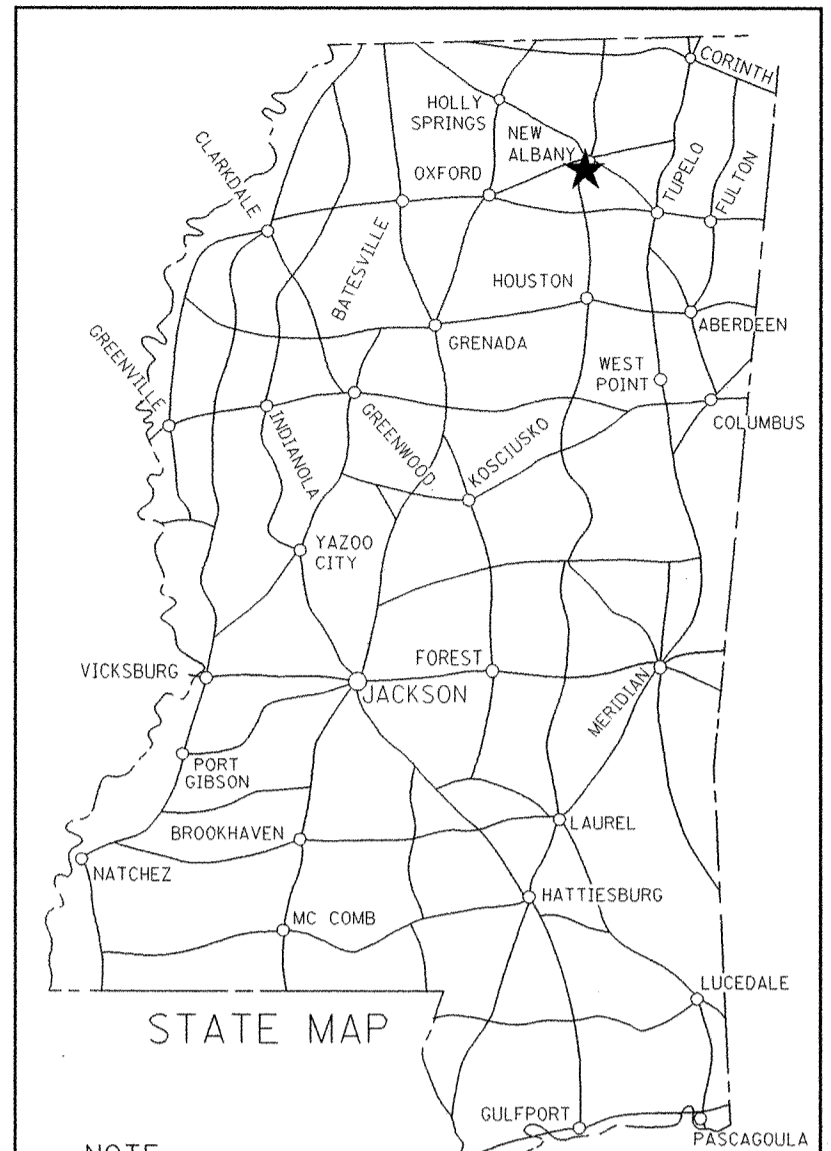

NOTE
★ INDICATES APPROXIMATE LOCATION OF PROJECT.
LAT. LONG.
(APPROX. MIDDLE OF PROJECT)

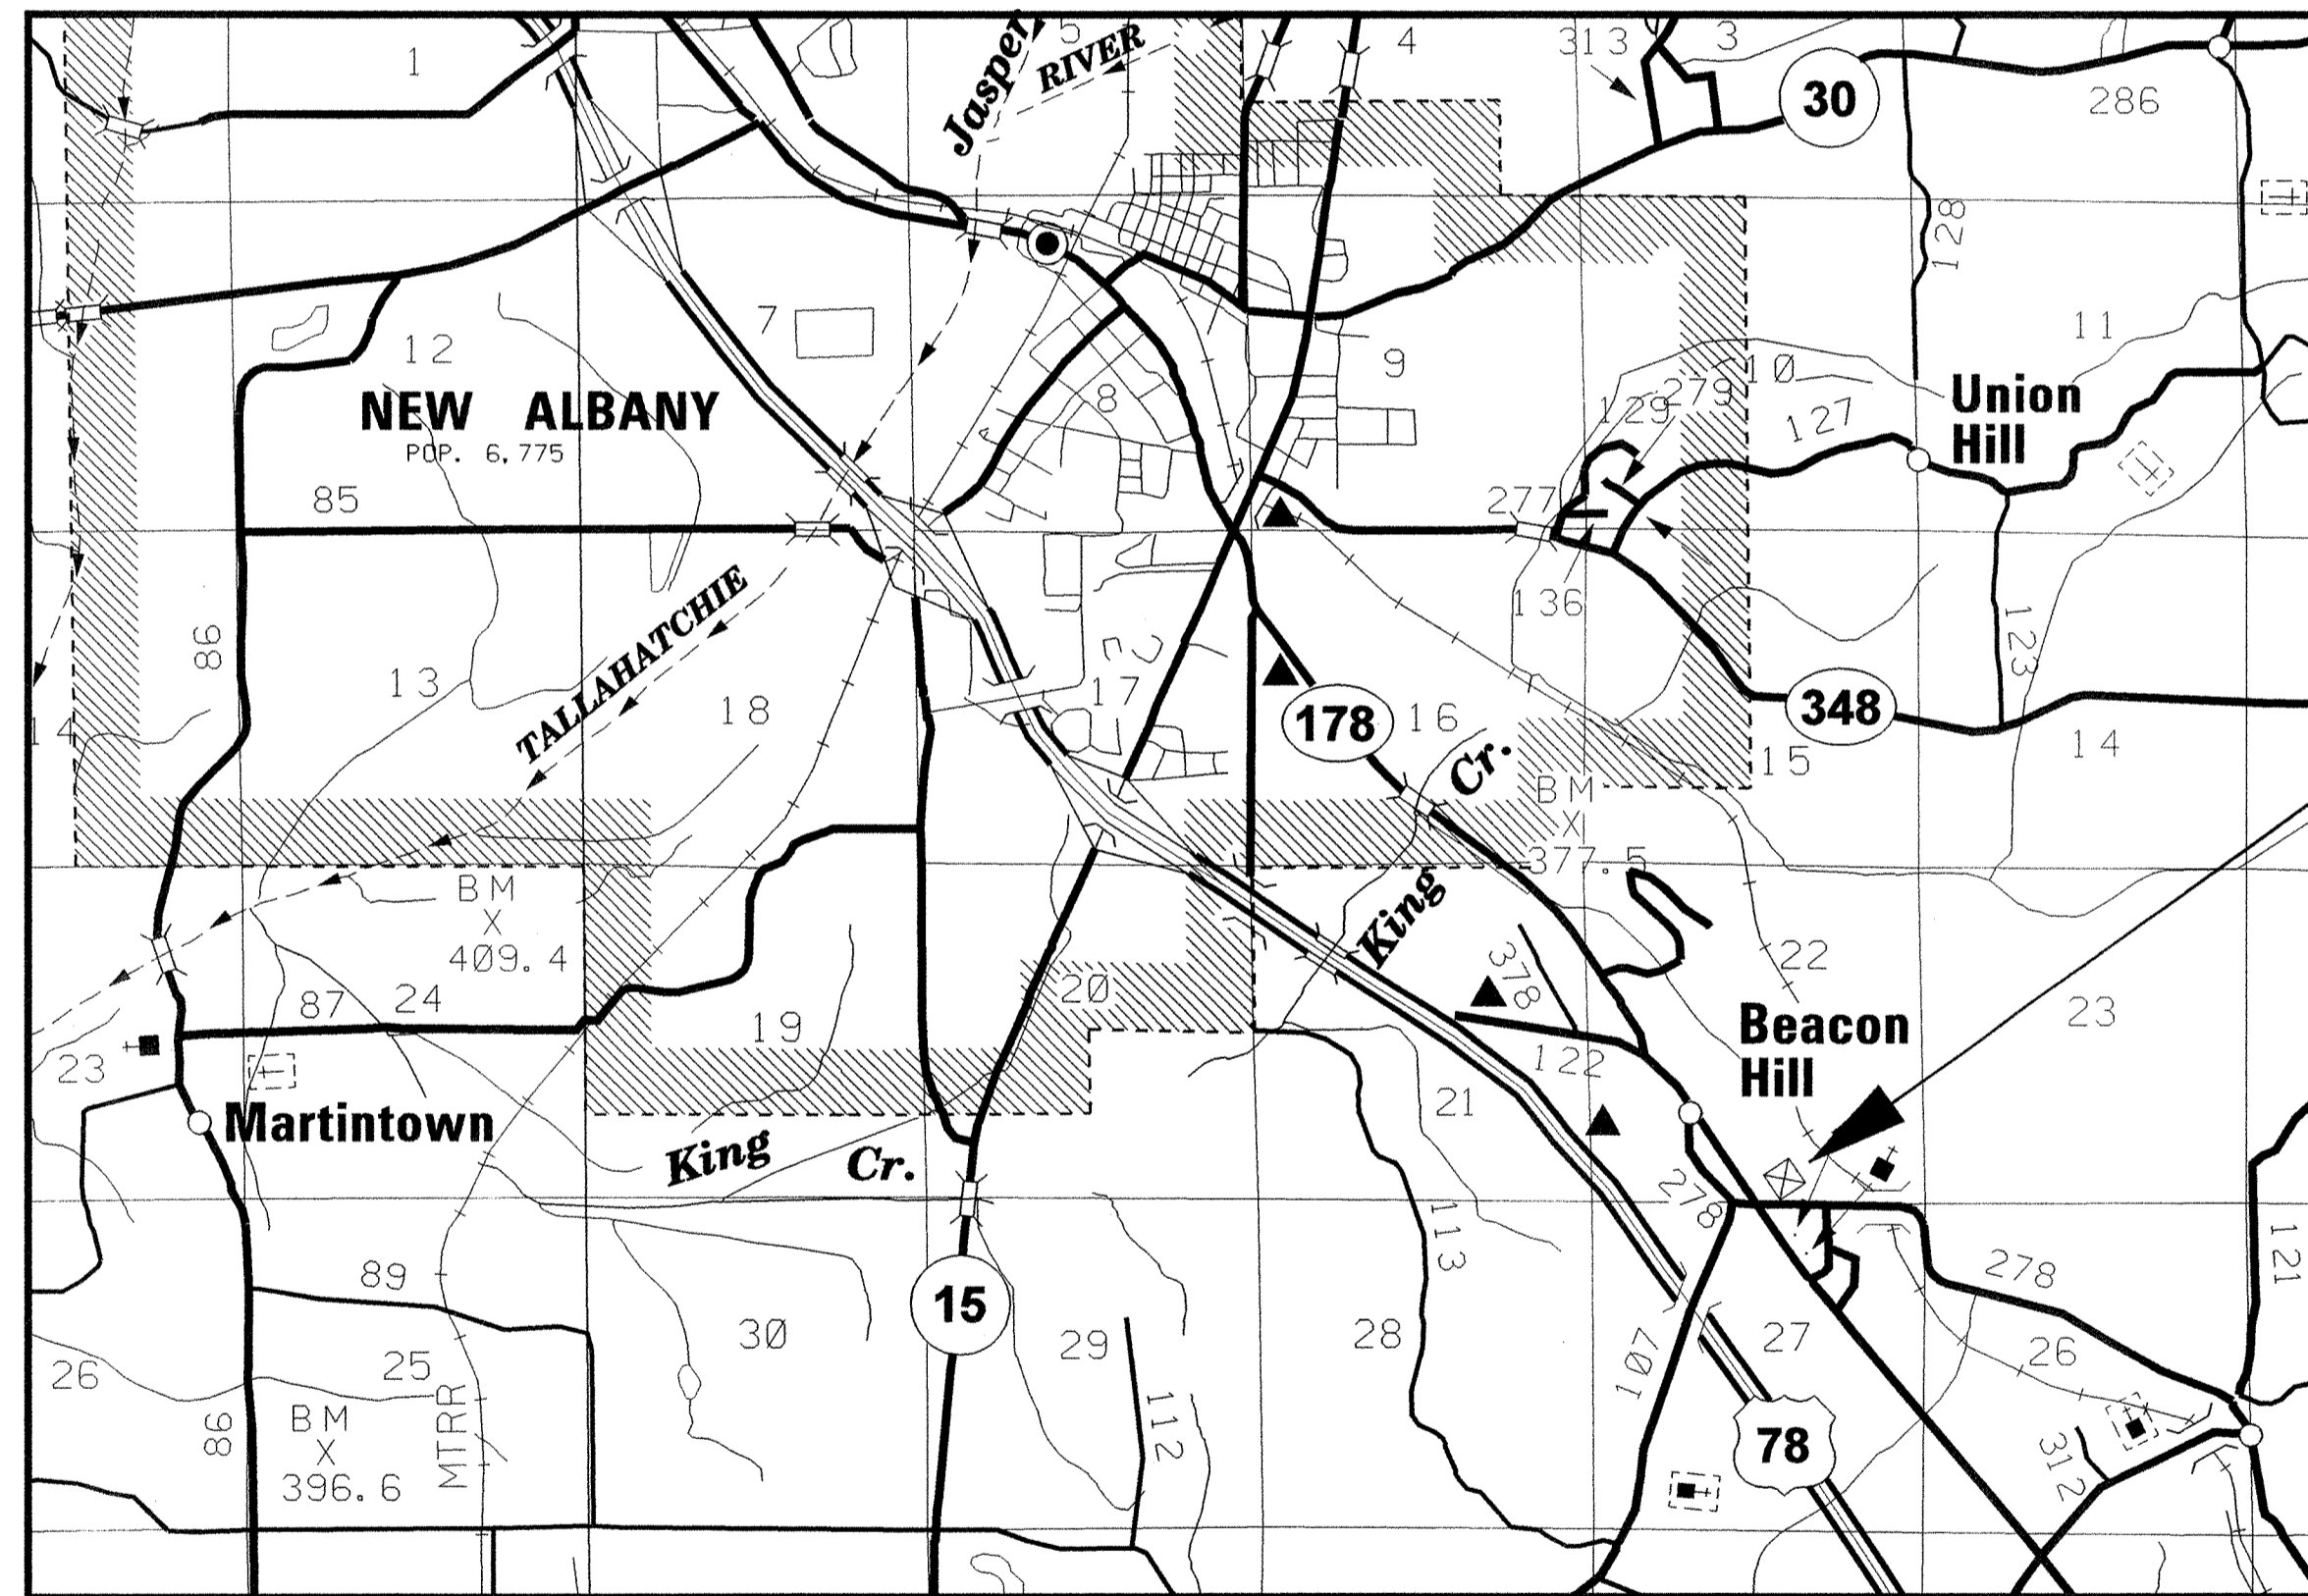

PROJECT OFFICE SITE
HWY 178

DESIGN CONTROL

MPH = V (SPEED DESIGN)

ADT () = : ADT () =

DHV = : D = % T = %

PERMITS ACQUIRED BY MDOT

WETLANDS AND WATERS PERMITS (NECESSARY FOR ULTIMATE IMPROVEMENTS ONLY):

	WATERS	WETLANDS
NATIONWIDE #14	N	N
NATIONWIDE (OTHER)*	N	N
GENERAL*	N	N
INDIVIDUAL (404)*	N	N

* ACQUISITION OF PERMITS FOR TEMPORARY IMPACTS DURING CONSTRUCTION ARE THE RESPONSIBILITY OF THE CONTRACTOR

STORMWATER PERMIT N

Y REQUIRED, CNOI SUBMITTED BY MDOT (DISTRIBUTED AREA = 5 ACRES) (NTB 6484)

S REQUIRED, SCNOI TO BE SUBMITTED BY CONTRACTOR (1 TO 4.99 ACRES) (NTB 6483)

N NO STORMWATER PERMIT REQUIRED (<1 ACRE)

APPROVED BY: *CV* DATE: 1-4-07

CONVENTIONAL SYMBOLS

- COUNTY LINE -----
- TOWN CORPORATION LINE -----
- SECTION LINE -----
- EXISTING ROAD OR TRAVELED WAY -----
- EXISTING DIVIDED HIGHWAY -----
- RAILROAD -----
- SURVEY LINE -----
- BRIDGES -----

APPROVED:	<i>Sammy Lufkin</i>	1/4/07
CHIEF ENGINEER		DATE
APPROVED:	<i>Sammy Lufkin</i>	1/4/07
EXECUTIVE DIRECTOR		DATE
MISSISSIPPI DEPARTMENT OF TRANSPORTATION		
APPROVED:		
DIVISION ADMINISTRATOR		DATE
FEDERAL HIGHWAY ADMINISTRATION DEPARTMENT OF TRANSPORTATION		

1/4/2007 11:43AM G0011.L.D01


DESCRIPTION OF SHEET

WKG. NO. SH. NO.

ABBREVIATIONS:

AFF ABOVE FINISH FLOOR
 BLDG BUILDING
 BOTT BOTTOM
 CJ CONTROL JOINT
 CLR CLEAR
 CONT CONTINUOUS
 DET DETAIL
 DIA DIAMETER
 (E) EXISTING
 EA EACH
 EJ EXPANSION JOINT
 ELEC ELECTRICAL
 EQL EQUAL
 ETR EXISTING TO REMAIN
 EXTR EXTRUDED
 FF FINISH FLOOR
 FT FEET
 GC GENERAL CONTRACTOR
 MECH MECHANICAL
 MET METAL
 NIC NOT IN CONTRACT
 OC ON CENTER
 PL PLATE
 REINF REINFORCING
 SCHD SCHEDULE
 TYP TYPICAL

SYMBOL LEGEND:

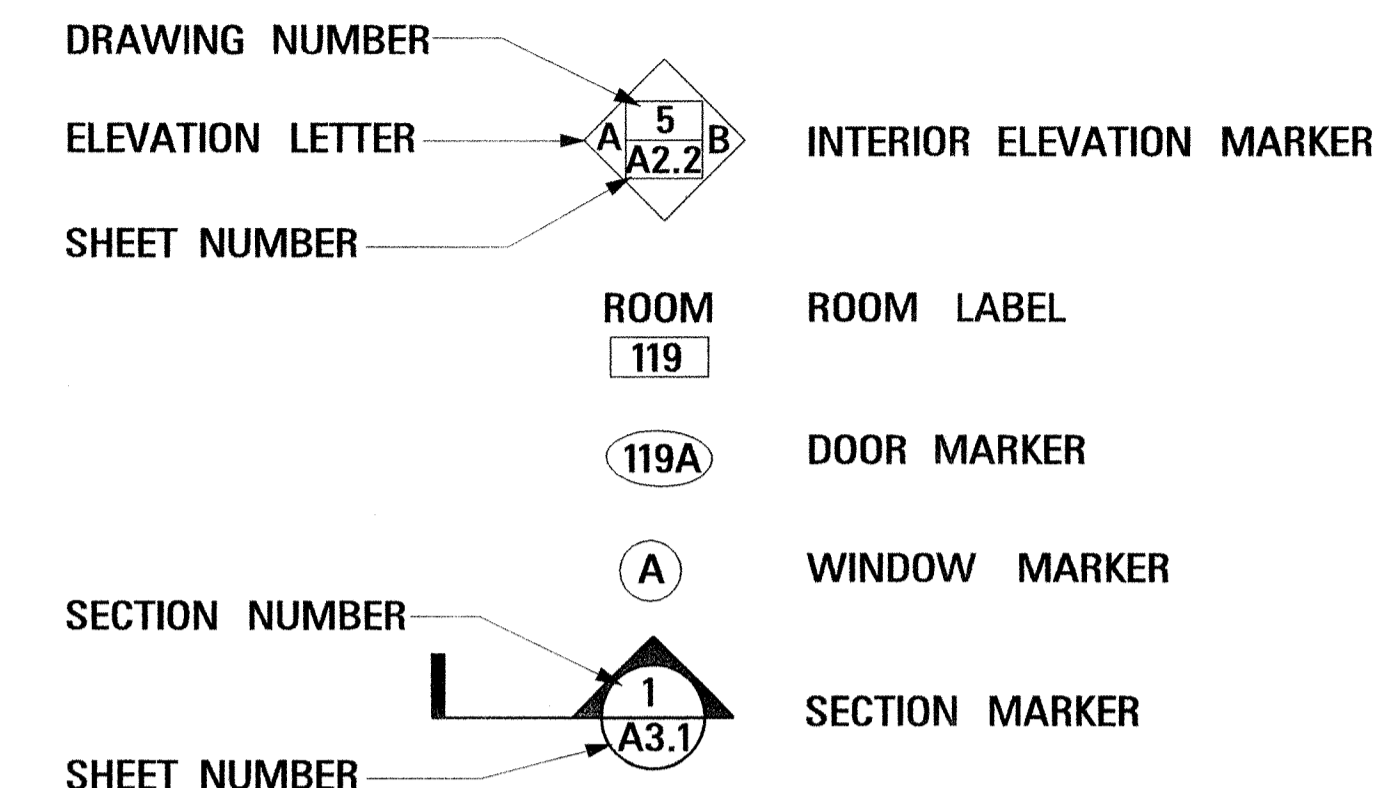

TITLE SHEET			1
DETAILED INDEX		DI-1	2
SITE PLAN		A1.1	3
FLOOR PLAN		A1.2	4
FOUNDATION PLAN AND DETAILS		A1.3	5
ROOF PLAN		A1.4	6
REFLECTED CEILING PLAN		A1.5	7
BUILDING ELEVATIONS		A2.1	8
INTERIOR VIEWS		A2.2	9
INTERIOR VIEWS (CONT'D.)		A2.3	10
WALL SECTIONS		A3.1	11
WALL SECTIONS (CONT'D.)		A3.2	12
FLOOR FINISH PLAN		A3.3	13
WALL AND CABINET SECTIONS		A4.1	14
PARTIAL FLOOR PLAN AND FLOOR FINISH PLAN		A4.2	15
DOOR AND WINDOW DETAILS		A5.1	16
SITE DETAILS		A5.2	17
DOOR OPENING AND FINISH SCHEDULE		A6.1	18
PLUMBING LEGEND, ABBREVIATIONS, AND GENERAL NOTES		P0.1	19
SITE PLAN - PLUMBING		P1.0	20
FLOOR PLAN - PLUMBING		P2.1	21
PLUMBING SCHEDULES, DETAILS, AND RISERS		P3.1	22
HVAC LEGEND, ABBREVIATIONS, AND GENERAL NOTES		M0.1	23
FLOOR PLAN - HVAC		M2.1	24
HVAC SCHEDULES		M3.1	25
HVAC DETAILS		M4.1	26
ELECTRICAL LEGEND, ABBREVIATIONS AND GENERAL NOTES		E0.1	27
SITE PLAN - ELECTRICAL		E1.0	28
FLOOR PLAN - LIGHTING		E2.1	29
FLOOR PLAN - POWER & COMMUNICATIONS		E2.2	30
FLOOR PLAN - SECURITY		E2.3	31
FLOOR PLAN - HVAC ELECTRICAL		E2.4	32
ELECTRICAL SCHEDULES AND POWER RISER DIAGRAM		E3.1	33
ELECTRICAL DETAILS		E4.1	34
ELECTRICAL DETAILS		E4.2	35
ELECTRICAL DEVICE ELEVATIONS		E4.3	36

PS & E PLANS-DATE 01/08/07		
FMS CON. # 501617/301000		
REVISIONS		
DATE	SHEET NO.	BY

MISSISSIPPI DEPARTMENT OF TRANSPORTATION PROJECT OFFICE BUILDING AT NEW ALBANY	
DETAILED INDEX	
BWO-1138-73(001) UNION COUNTY	
WORKING NUMBER DI-1	ASU
FILENAME: DI-1.DGN	SHEET NUMBER 2
DATE: 01/08/07	DESIGN TEAM: PARKER CHECKED: JWV DATE: 01/08/07

1/8/2007 9:26 AM DI-1.DGN MISSISSIPPI DEPARTMENT OF TRANSPORTATION PLAN ROOM: 01