

FED. ROAD REG. NO.	STATE	PROJECT NO.	SHEET NO.
4	MISS.		1

GENERAL INDEX

FOR DETAILED INDEX OF PLANS SEE SHEET NO. 2

DESCRIPTION	NUMBER OF SHEETS
TITLE SHEET	1
DETAILED INDEX	1
GENERAL NOTES	
TYPICAL SECTIONS	
QUANTITIES	
PLAN AND PROFILES	
SPECIAL DESIGN - BUILDINGS	30
BRIDGE DRAWINGS	
SPECIAL DESIGN - BRIDGES	
CROSS-SECTIONS	
SPECIAL DESIGN - FENCING	1
TOTAL SHEETS	33



STATE OF MISSISSIPPI
MISSISSIPPI DEPARTMENT OF TRANSPORTATION

**PLANS OF PROPOSED
TRAINING CENTER WITH OFFICES
AT DISTRICT TWO COMPLEX
AT BATESVILLE
STATE PROJECT NO. BWO-2200-54(001)**

①3-6-08

501763/301000

PANOLA COUNTY

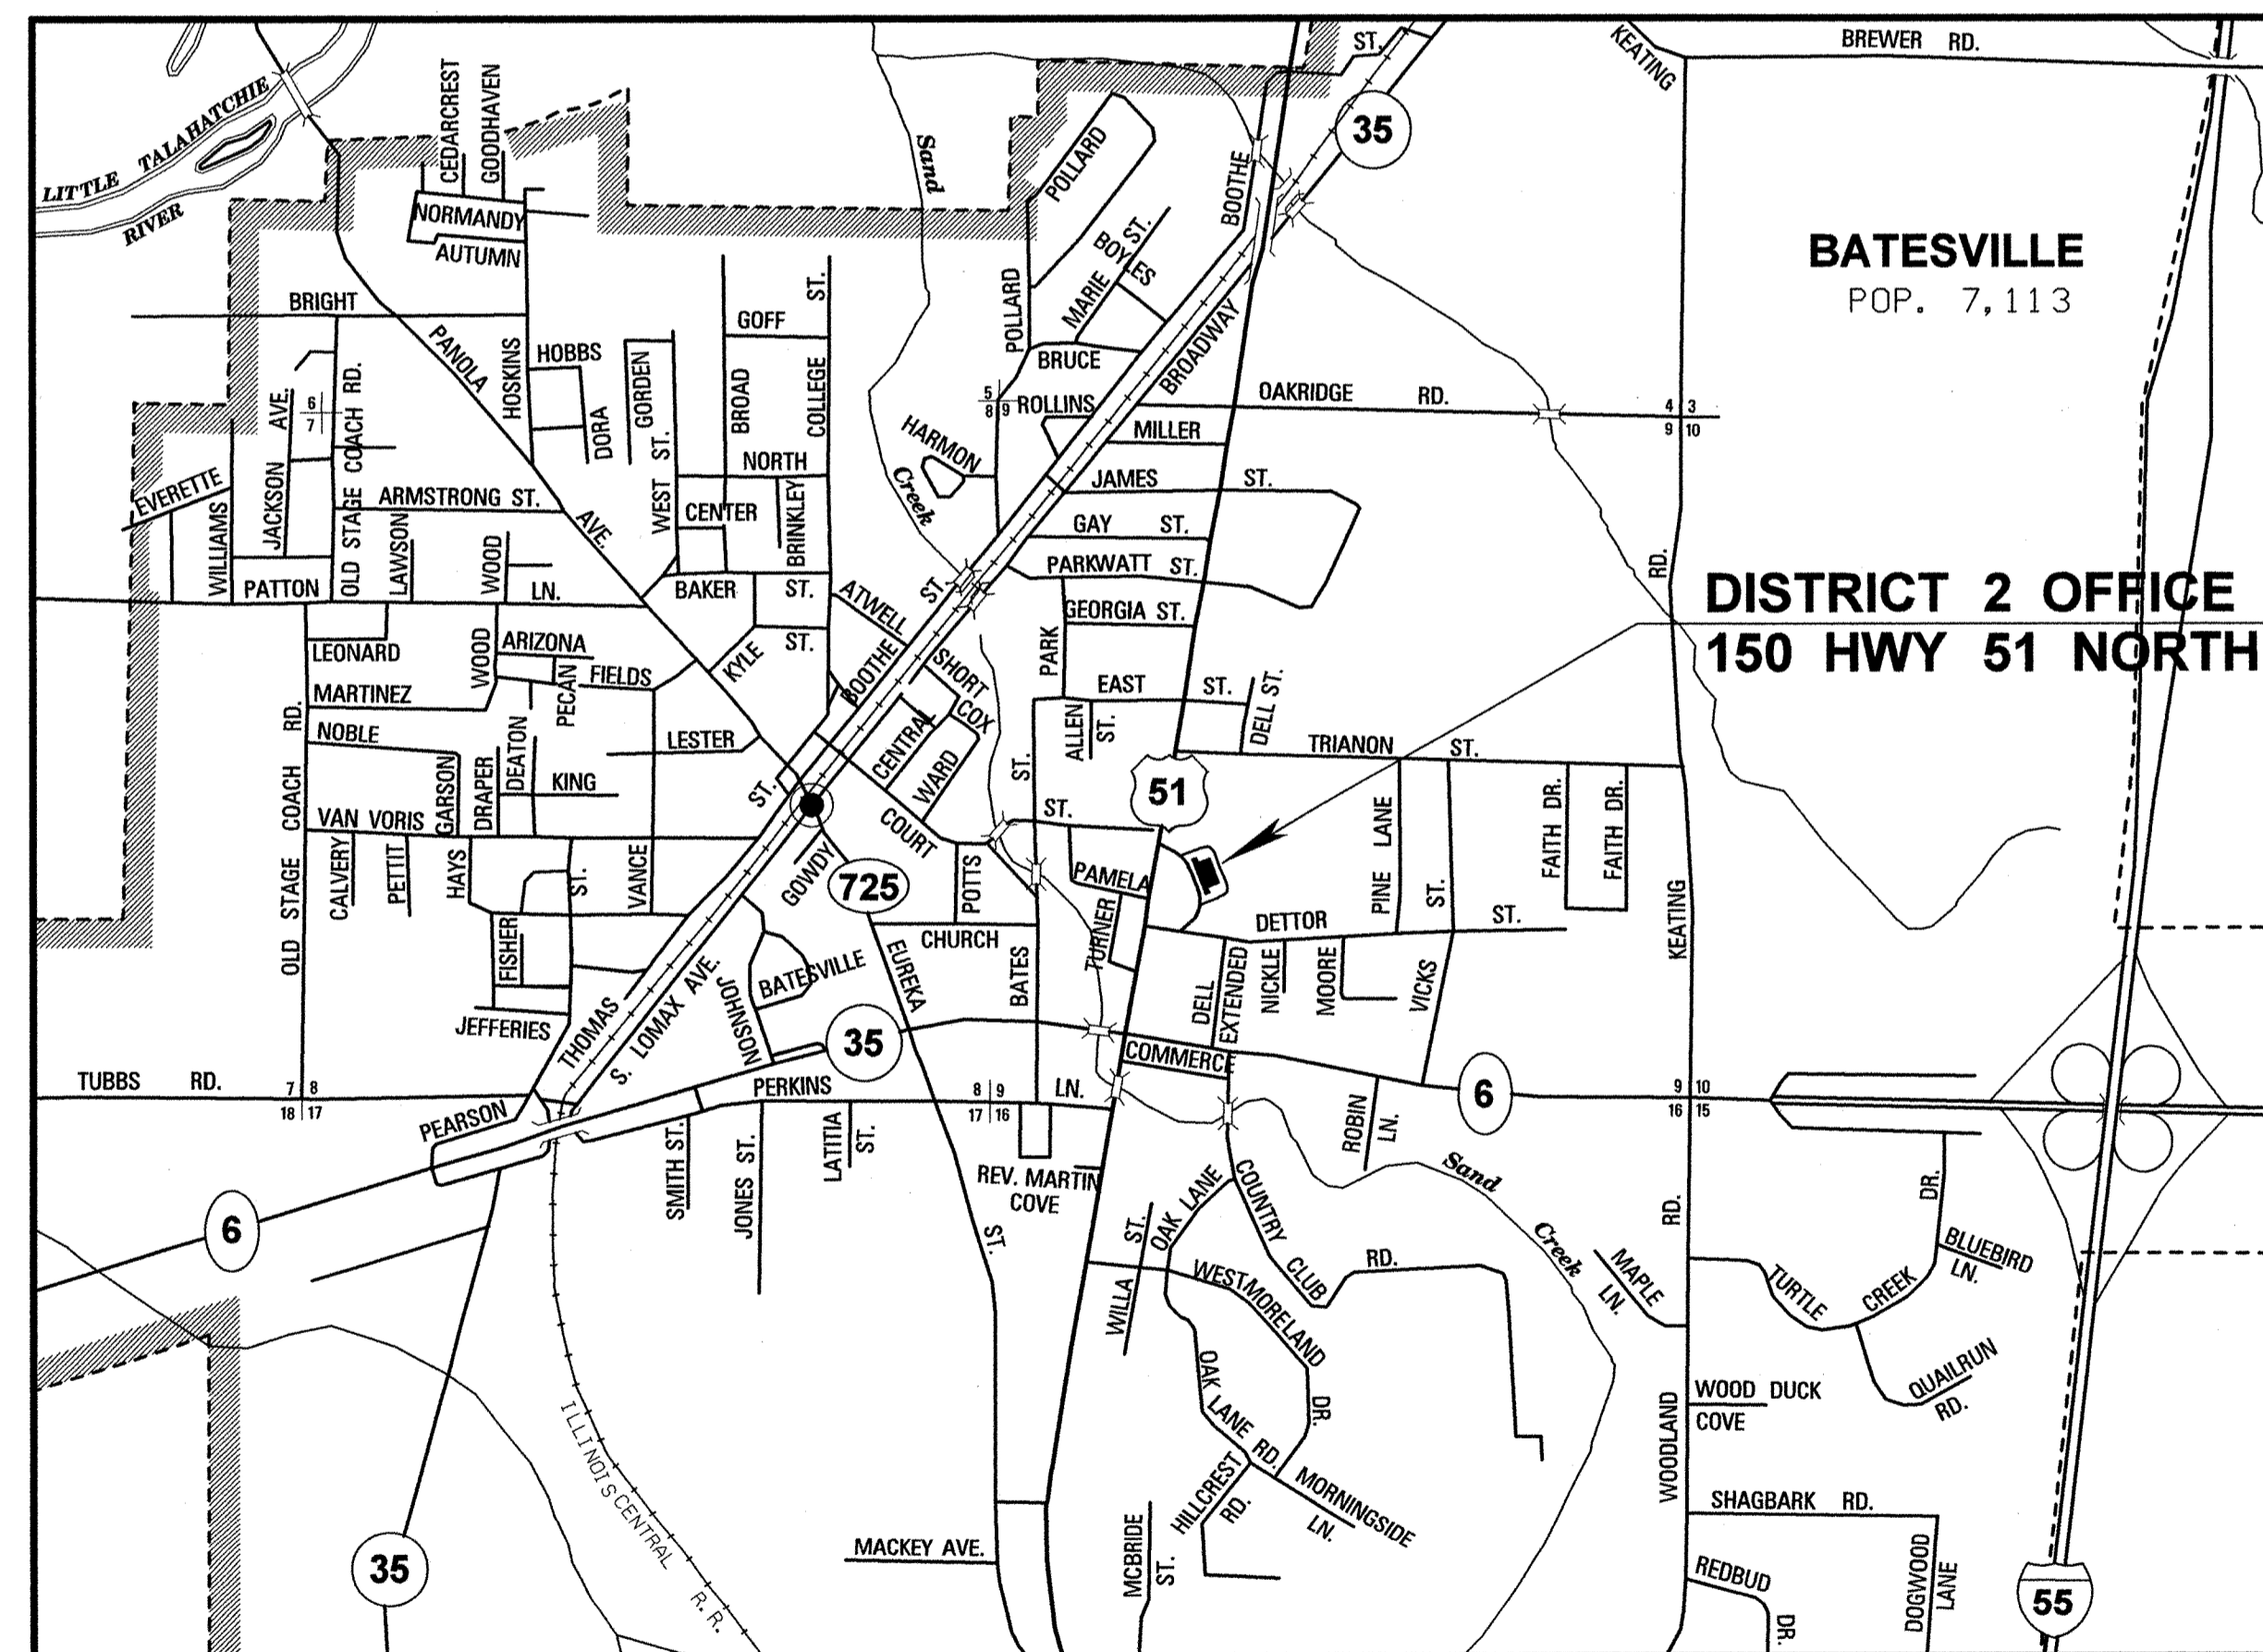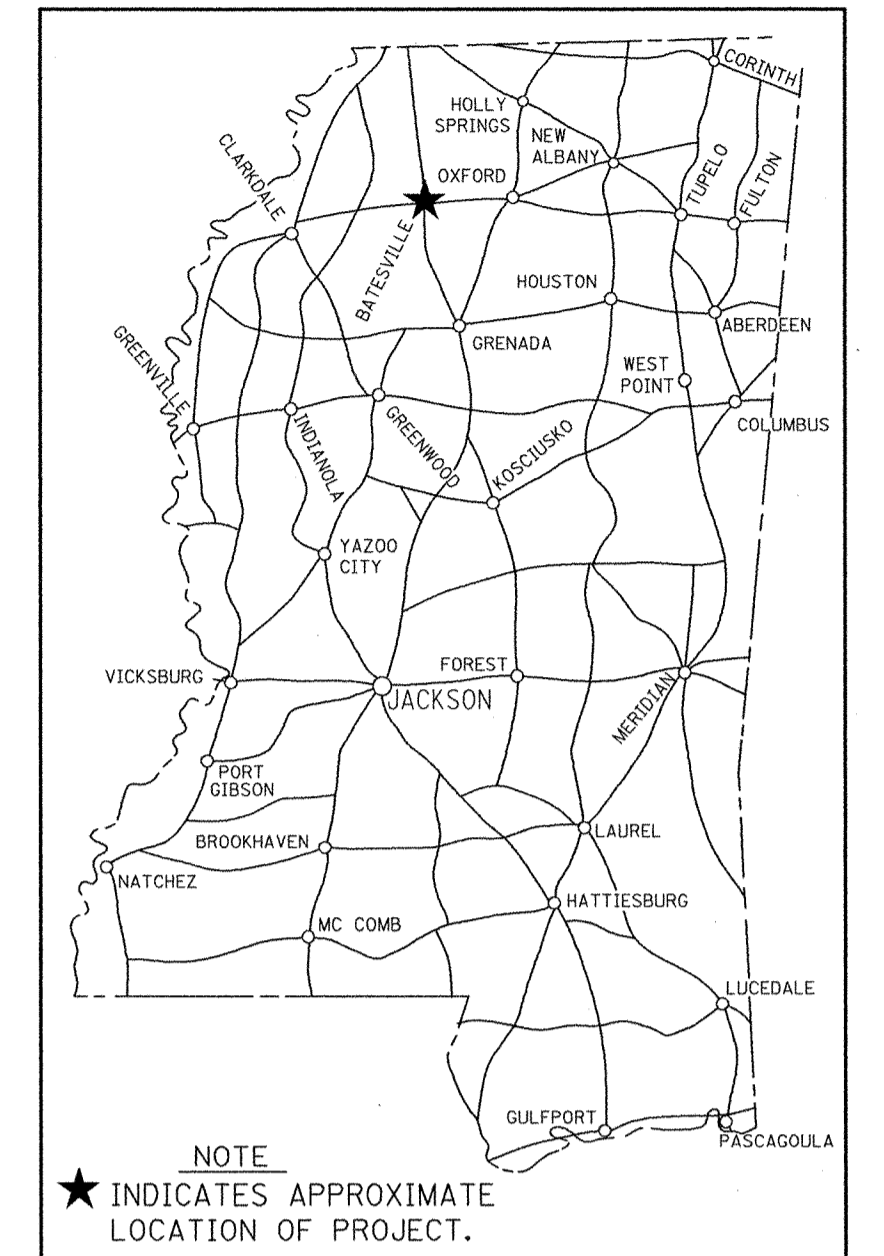

DESIGN CONTROL		
MPH =	V (SPEED DESIGN)	
ADT () =	:	ADT () =
DHV =	:	D = % T = %
PERMITS ACQUIRED BY MDOT		
WETLANDS AND WATERS PERMITS (NECESSARY FOR ULTIMATE IMPROVEMENTS ONLY):		
NATIONWIDE #14	<input type="checkbox"/> WATERS	<input type="checkbox"/> WETLANDS
NATIONWIDE (OTHER)*	<input type="checkbox"/>	<input type="checkbox"/>
GENERAL*	<input type="checkbox"/>	<input type="checkbox"/>
INDIVIDUAL (404)*	<input type="checkbox"/>	<input type="checkbox"/>
* ACQUISITION OF PERMITS FOR TEMPORARY IMPACTS DURING CONSTRUCTION ARE THE RESPONSIBILITY OF THE CONTRACTOR		
STORMWATER PERMIT <input checked="" type="checkbox"/>		
Y	REQUIRED, CNOI SUBMITTED BY MDOT (DISTRIBUTED AREA = 5 ACRES + INTB 6484)	
S	REQUIRED, SCNOI TO BE SUBMITTED BY CONTRACTOR (1 TO 4.99 ACRES) (INTB 6483)	
N	NO STORMWATER PERMIT REQUIRED (<1 ACRE)	
APPROVED BY:	<i>[Signature]</i>	DATE: 3-3-08

CONVENTIONAL SYMBOLS

- COUNTY LINE -----
- TOWN CORPORATION LINE -----
- SECTION LINE -----
- INTERSTATE OR DIVIDED HIGHWAY -----
- OTHER HIGHWAY OR CITY STREET -----
- RAILROAD -----
- SURVEY LINE -----
- BRIDGES -----

DATE	REVISIONS	BY	APPROVED:	DATE
			<i>Harry Lee James</i>	3/5/08
			CHIEF ENGINEER	DATE
			<i>Raymond R. Brown</i>	3/5/08
			EXECUTIVE DIRECTOR	DATE
			MISSISSIPPI DEPARTMENT OF TRANSPORTATION	
			APPROVED:	
			DIVISION ADMINISTRATOR	DATE
			FEDERAL HIGHWAY ADMINISTRATION DEPARTMENT OF TRANSPORTATION	

FOUNDATION PLAN AND CONCRETE DETAILS
DESCRIPTION OF SHEET


WKG. NO. SH. NO.

TITLE SHEET		—	1
DETAILED INDEX		DI-1	2
SITE PLAN		A1.1	3
FLOOR PLAN		A1.2	4
ROOF PLAN		A1.3	5
REFLECTED CEILING PLAN		A1.4	6
FLOOR FINISHES PLAN		A1.5	7
BUILDING ELEVATIONS		A2.1	8
INTERIOR ELEVATIONS		A2.2	9
WALL SECTIONS		A3.1	10
WALL SECTIONS		A3.2	11
MILLWORK SECTIONS AND MISCELLANEOUS DETAILS		A4.1	12
DOOR AND WINDOW DETAILS		A5.1	13
MISCELLANEOUS SITE DETAILS		A5.2	14
DOOR OPENING AND FINISH SCHEDULE		A6.1	15
FOUNDATION PLAN AND DETAILS		S1.1	16
PLUMBING LEGEND, ABBREVIATIONS, AND GENERAL NOTES		P0.1	17
SITE PLAN - PLUMBING		P1.0	18
FLOOR PLAN - PLUMBING		P2.1	19
PLUMBING SCHEDULES, DETAILS, AND RISERS		P3.1	20
HVAC LEGEND, ABBREVIATIONS, AND GENERAL NOTES		M0.1	21
FLOOR PLAN - HVAC		M2.1	22
HVAC SCHEDULES		M3.1	23
HVAC DETAILS		M4.1	24
ELECTRICAL LEGEND, ABBREVIATIONS AND GENERAL NOTES		E0.1	25
SITE PLAN - ELECTRICAL		E1.0	26
FLOOR PLAN - LIGHTING		E2.1	27
FLOOR PLAN - POWER & COMMUNICATIONS		E2.2	28
FLOOR PLAN - EQUIPMENT POWER		E2.3	29
FLOOR PLAN - CONDUIT PLAN FOR SECURITY SYSTEMS		E2.4	30
ELECTRICAL DETAILS		E3.1	31
ELECTRICAL SCHEDULES AND POWER RISER DIAGRAM		E4.1	32
FENCE: CHAIN LINK CLASS I (W/LATTICE)		CL-1L	33

ABBREVIATIONS:

- AFF ABOVE FINISH FLOOR
- AFS AT FULL SCALE
- BLDG..... BUILDING
- BOTT..... BOTTOM
- CJ CONTROL JOINT
- CLR CLEAR
- CONT..... CONTINUOUS
- DET DETAIL
- DIA DIAMETER
- (E) EXISTING
- EA EACH
- EJ EXPANSION JOINT
- ELEC..... ELECTRICAL
- EQL EQUAL
- ETR EXISTING TO REMAIN
- EXTR..... EXTRUDED
- FF FINISH FLOOR
- FT FEET
- GC GENERAL CONTRACTOR
- MECH..... MECHANICAL
- MET METAL
- NIC NOT IN CONTRACT
- OC ON CENTER
- PL PLATE
- REINF..... REINFORCING
- SCHD..... SCHEDULE
- TYP TYPICAL

SYMBOL LEGEND:

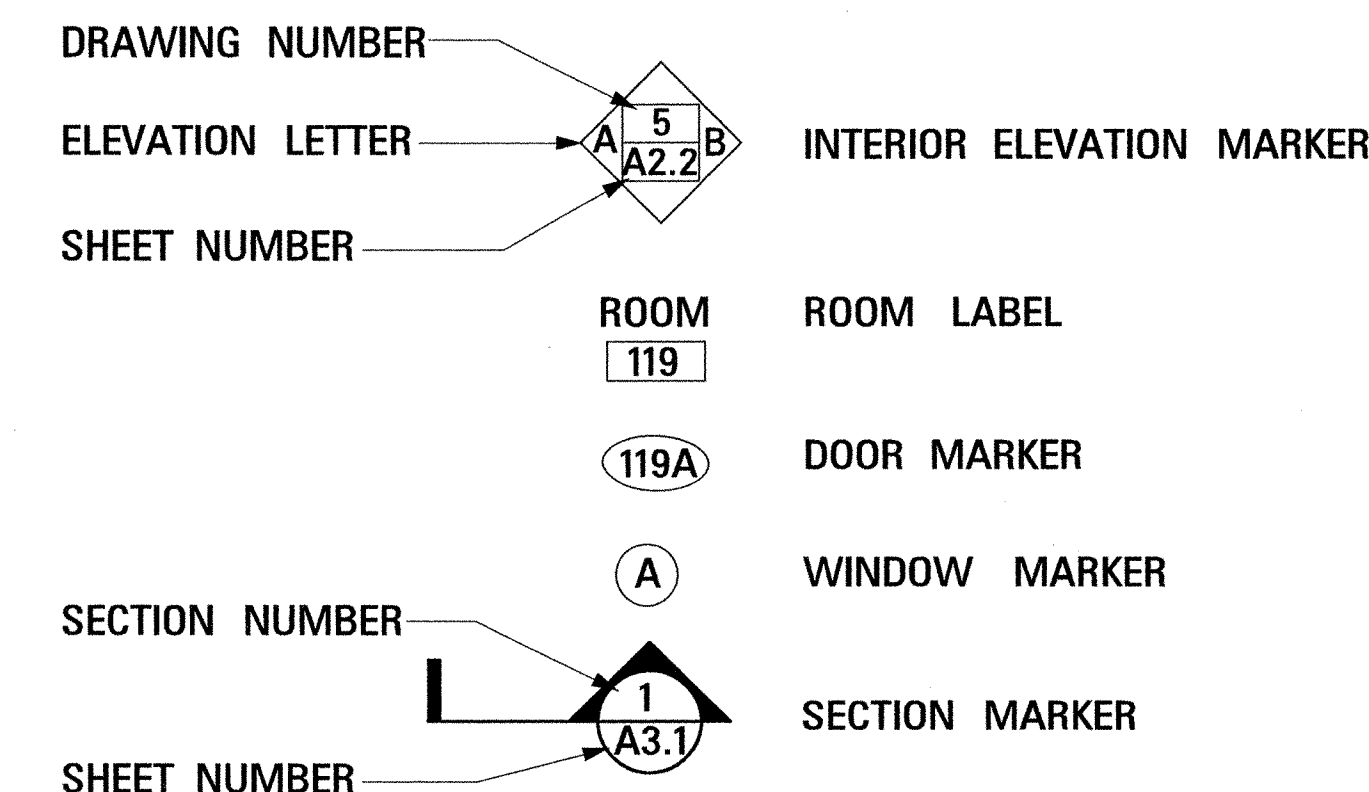

PROJECT SUMMARY OF QUANTITIES

PAY ITEM NO.	DESCRIPTION	UNIT	PRELIM.	FINAL
1500-A	CONSTRUCTION OF TRAINING CENTER WITH OFFICES FOR DISTRICT TWO COMPLEX AT BATESVILLE, PANOLA COUNTY	LUMP SUM	L. S.	

PS & E PLANS-DATE..3/06/08		
FMS CON. # 501763/301000		
REVISIONS		
DATE	SHEET NO.	BY

ASU

MISSISSIPPI DEPARTMENT OF TRANSPORTATION	
TRAINING CENTER WITH OFFICES AT DISTRICT TWO COMPLEX AT BATESVILLE	
DETAILED INDEX	
BWO-2200-54(001) PANOLA COUNTY	
DATE	WORKING NUMBER
FILENAME: DI-1.DGN	DI-1
DESIGN TEAM: PARKER CHECKED: JWV DATE: 3/03/08	SHEET NUMBER: 2

3/5/2008 11:03 AM DI-1.DGN