

STATE	PROJECT NUMBER	SHEET NO.
MISSISSIPPI	NH-0056-01(098)	1

GENERAL INDEX

INCLUDED THIS PROJECT	BEGIN WITH SHEET
<input checked="" type="checkbox"/> ROADWAY	1
<input type="checkbox"/> PERMANENT SIGNS	1001
<input type="checkbox"/> TRAFFIC SIGNALS	2001
<input type="checkbox"/> ITS COMPONENTS	3001
<input type="checkbox"/> LIGHTING	4001
<input type="checkbox"/> (RESERVED)	5001
<input checked="" type="checkbox"/> ROADWAY STANDARD DWGS	6001
<input type="checkbox"/> BOX CULVERT STD. DRAWINGS (LRFD)	7001
<input type="checkbox"/> BOX CULVERT STD. DRAWINGS (STD. SPEC.)	7501
<input type="checkbox"/> STRUCTURES	8001
<input type="checkbox"/> CROSS SECTIONS	9001

BRIDGE STRUCTURES REQ'D.

BOX BRIDGES REQ'D.



STATE OF MISSISSIPPI
MISSISSIPPI DEPARTMENT OF TRANSPORTATION
PLAN AND PROFILE OF PROPOSED
STATE HIGHWAY
FEDERAL AID PROJECT NO. NH-0056-01(098)

SR 25 FROM SR OLD HWY 25
 TO OKTIBBEHA COUNTY LINE
 WINSTON COUNTY

FMS. CONST. NO. 107677/301000

SCALES

PLAN	1 IN. = 100 FT.
PROFILE {	HOR. 1 IN. = 100 FT.
	VERT. 1 IN. = 10 FT.
LAYOUT	1 IN. = FT.

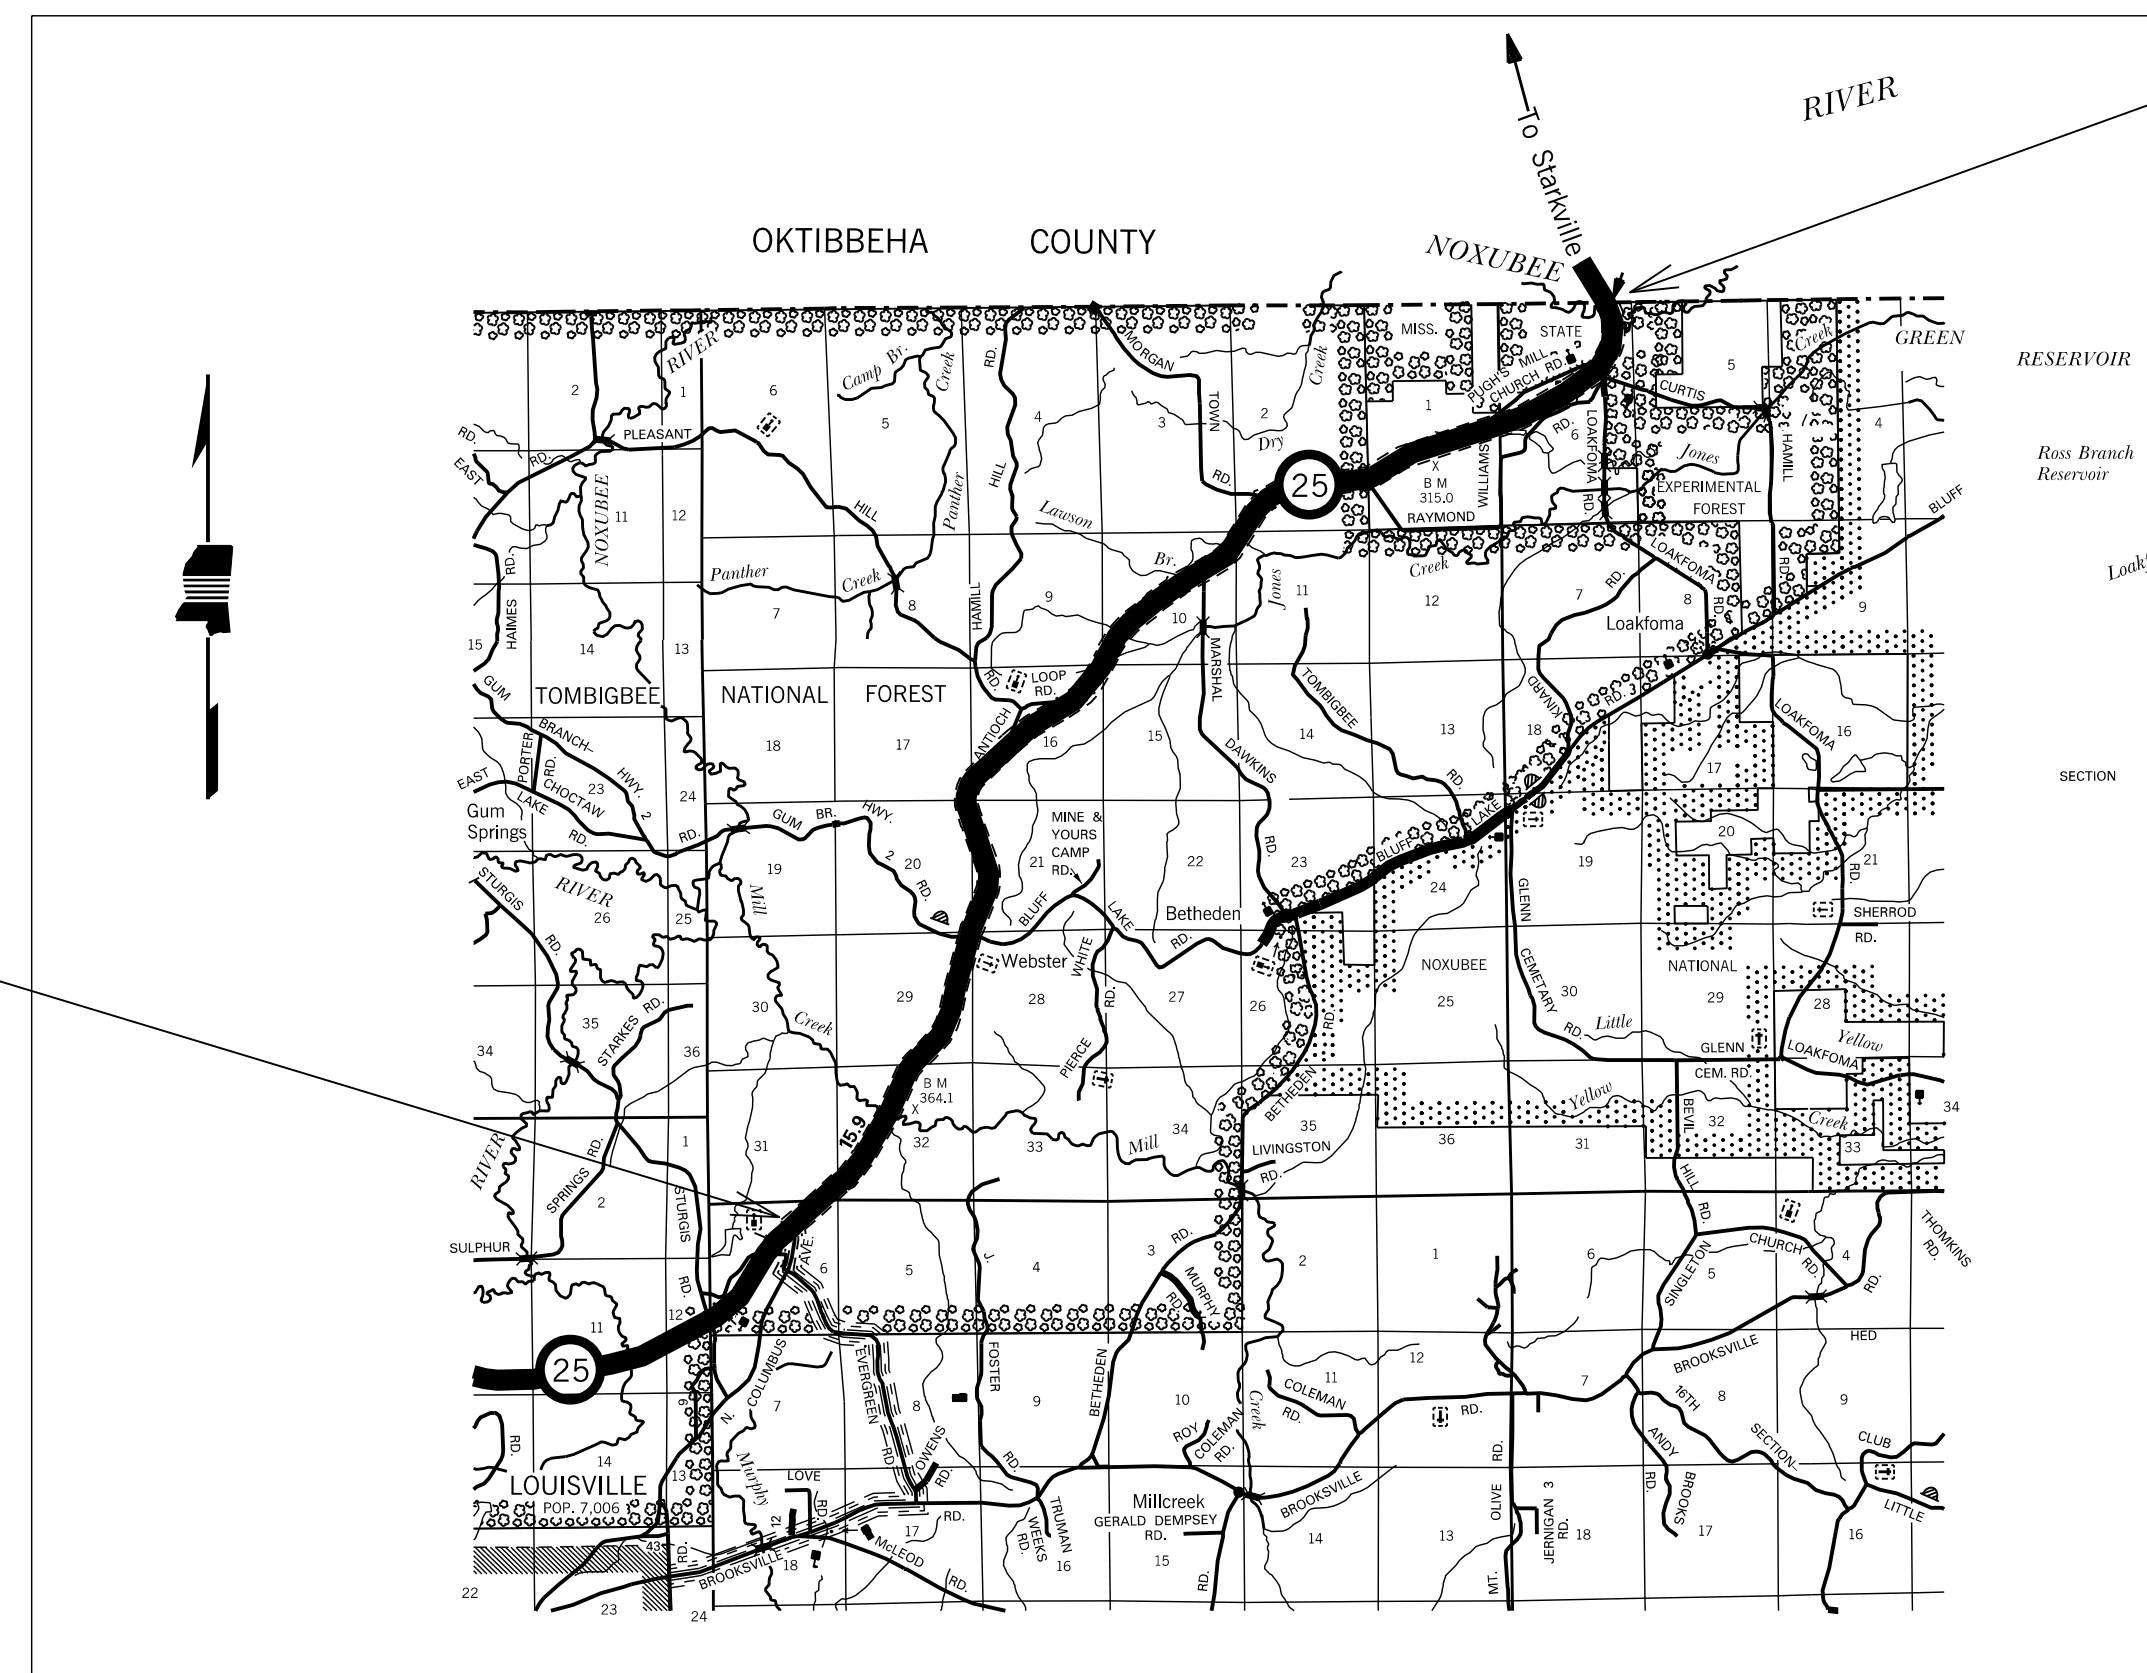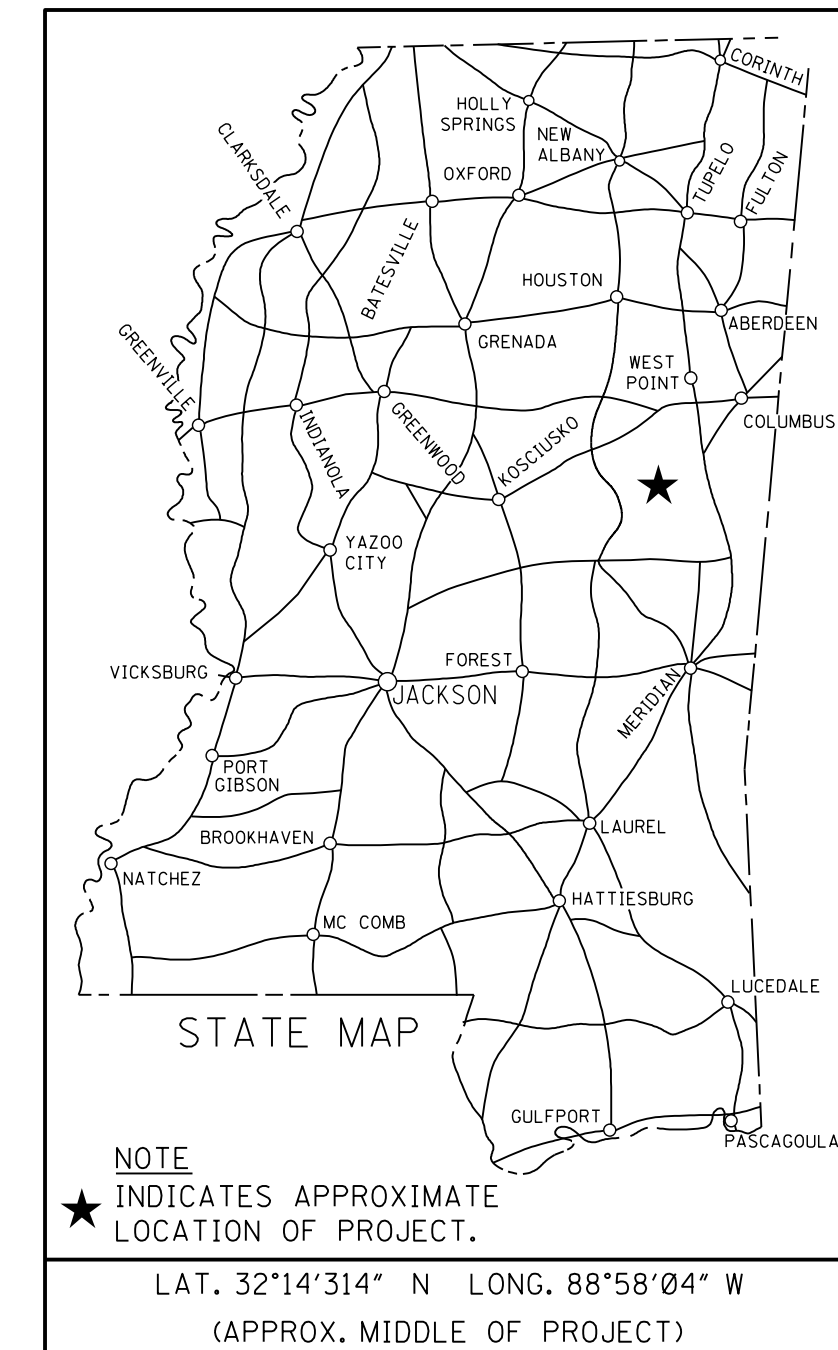

B.O.P. STA. 32 + 45

E.O.P. STA. 562 + 30.79

CONVENTIONAL SYMBOLS

COUNTY LINE	-----
TOWN CORPORATION LINE	-----
SECTION LINE	-----
EXISTING ROAD OR TRAVELED WAY	-----
PROPOSED ROAD OR TRAVELED WAY	-----
RAILROAD	-----
SURVEY LINE	-----
BRIDGES	-----

EQUATIONS
NONE

LENGTH DATA

LENGTH OF ROADWAY	52,533.79 FT.	9.950 MI.
LENGTH OF BRIDGES	452.00 FT.	0.055 MI.
LENGTH OF PROJECT (NET)	52,985.79 FT.	10.085 MI.
LENGTH OF EXCEPTIONS	0.00 FT.	0.00 MI.
LENGTH OF PROJECT (GROSS)	52,985.79 FT.	10.035 MI.

EXCEPTIONS
NONE

DESIGN CONTROL
 MPH = V (SPEED DESIGN)

ADT () = : ADT () =
 DHV = : D = % T = %

PERMITS ACQUIRED BY MDT

WETLANDS AND WATERS PERMITS (NECESSARY FOR ULTIMATE IMPROVEMENTS ONLY):

	WATERS	WETLANDS
NATIONWIDE #14	<input type="checkbox"/>	<input type="checkbox"/>
NATIONWIDE (OTHER)*	<input type="checkbox"/>	<input type="checkbox"/>
GENERAL*	<input type="checkbox"/>	<input type="checkbox"/>
INDIVIDUAL (404)*	<input type="checkbox"/>	<input type="checkbox"/>

* ACQUISITION OF PERMITS FOR TEMPORARY IMPACTS DURING CONSTRUCTION ARE THE RESPONSIBILITY OF THE CONTRACTOR

STORMWATER PERMIT

Y	REQUIRED, CNOI SUBMITTED BY MDT (DISTURBED AREA = 5 ACRES)
S	REQUIRED, CNOI TO BE SUBMITTED BY CONTRACTOR (1 TO 4.99 ACRES)
N	NO STORMWATER PERMIT REQUIRED (<1 ACRE)

APPROVED BY: _____

P S & E DATE: 7/1/2018

APPROVED: _____
 DEPUTY EXECUTIVE DIRECTOR / CHIEF ENGINEER

EXECUTIVE DIRECTOR _____



6/22/2018 7:04 AM HWY 25 N WINSTON CO. - 2018.DGN TITLE DIVISION MISSISSIPPI DEPARTMENT OF TRANSPORTATION

STATE	PROJECT NO.
MISS.	NH-0056-01(098)

DESCRIPTION OF SHEET

REVISION DATE WKG. NO. SH. NO.

TITLE SHEET (1)			1
DETAIL INDEX & GENERAL NOTES (1)		DI-1	2
TYPICAL OVERLAY SECTIONS (1)			
TYPICAL OVERLAY SECTION FOUR LANE ROADWAY HWY 45		TS-1	3
QUANTITY SHEETS (2)			
SUMMARY OF QUANTITIES		SQ-1	4
SUMMARY OF QUANTITIES		SQ-2	5
SPECIAL DESIGN-ROADWAY ITEMS (2)			
DETAIL OF CONSTRUCTION SIGNS HWY 25		DSC-1	6
DETAIL OF CONSTRUCTION SIGNS HWY 25		DSC-2	7
STANDARD DRAWINGS - ROADWAY SHEETS (16)			
PAVEMENT MARKING DETAIL FOR 2-LANE AND 4-LANE DIVIDED HIGHWAYS		PM-1	6051
TYPICAL PAVEMENT MARKING DETAIL MEDIAN CROSSEOVERS		PM-9	6059
2-WAY RAISED PAVEMENT MARKERS AT INTERSECTING ROADS (4-LANE)		PM-12	6062
RUMBLE STRIPES 4-LANE HIGHWAYS (ASPHALT LANES, 2-FT OR WIDER ASPHALT SHOULDERS)		RS-2	6065
GUARDRAIL: "W" BEAM (STEEL POST)		GR-1B	6203
GUARDRAIL: BRIDGE END SECTION TYPE "H" (STEEL POST)		GR-2D	6208
GUARDRAIL: TYPICAL INSTALLATION AT BRIDGE APPROACHES FOR DIVIDED HIGHWAYS		GR-4	6214
GUARDRAIL: MISCELLANEOUS HARDWARE		GR-HW	6221
TYPICAL GUARDRAIL DELINEATION		SN-8C	6317
TRAFFIC CONTROL PLAN FOR POSTED SPEED LIMIT OF 65 OR 70 MPH (INTERSTATE AND OTHER 4-LANE DIVED HIGHWAYS) (MEDIAN LANE OR OUTSIDE LANE CLOUSER) (EXTENDED PERIOD)		TCP-4	6354
TRAFFIC CONTROL PLAN FOR POSTED SPEED LIMIT OF 65 OR 70 MPH (INTERSTATE AND OTHER 4-LANE DIVIDED HIGHWAYS) (MEDIAN LANE OR OUTSIDELANE CLOSURE) (WORK DAY ONLY)		TCP-5	6355
HIGHWAY SIGN AND BARRICADE DETAILS FOR CONSTRUCTION PROJECTS		TCP-8	6358
TRAFFIC CONTROL PLAN MOBILE OPERATIONS MULTILANE ROADS AND TWO LANE ROADS		TCP-9	6359
TRAFFIC CONTROL PLAN UNEVEN PAVEMENT DETAILS		TCP-12	6362
TEMPORARY STRIPING FOR TRAFFIC CONTROL 2-LANE AND 4-LANE DIVIDED HIGHWAYS		TCP-13	6363
LOCATION OF R16-3 SIGNS		TCP-15	6365

GENERAL NOTES:

- ① WHERE MILLING OF THE ROADWAY LANES IS REQUIRED, THE CONTRACTOR SHALL PROVIDE OUTLETS IN THE EXISTING SHOULDERS AT SUFFICIENT INTERVALS TO PREVENT POOLING OR STANDING WATER ON THE MILLED SURFACE. (ABSORBED COST)
- ② FLUORESENT ORANGE SHEETING SHALL BE USED ON ALL CONSTRUCTION AND TRAFFIC CONTROL SIGNS EXCEPT FOR THOSE DESIGNATED ON THE PLANS TO BE BLACK LEGEND AND BORDER ON THE WHITE BACKGROUND.
- ③ THE LOCATION AND SPACING OF SIGNS, SHOWN ON THE TRAFFIC CONTROL PLANS, ARE APPROXIMATE AND MAY BE ADJUSTED AS NECESSARY TO FIT FIELD CONDITIONS.
- ④ ALL TRAFFIC CONTROL DEVICES ON THIS PROJECT SHALL COMPLY WITH PART VI OF THE MUTCD (LATEST EDITION).
- ⑤ THIS CONTRACT IS TO INCLUDE FINE GRADING OF EXISTING AGGREGATE BASE
- ⑥ REMOVAL OF RAISED PAVEMENT MARKERS THAT ARE IN CONFLICT WITH REQUIRED CONSTRUCTION IS NOT CONSIDERED A SEPARATE PAY ITEM. COST TO BE ABSORBED INTO OTHER ITEMS BID.
- ⑦ BIDDERS ARE ADVISED THAT HARD COPIES OF ANY ADDENDA FOR THIS PROJECT WILL NO LONGER BE MAILED. ALL ADDENDA FOR THIS PROJECT WILL BE POSTED TO www.mdot.ms.gov UNDER THE PROPOSAL ADDENDA COLUMN. IT IS THE BIDDERS RESPONSIBILITY TO CHECK AND SEE IF ANY ADDENDA HAVE BEEN POSTED FOR THIS PROJECT. PLEASE CONTACT CONTRACT ADMINISTRATION DIVISION AT 601-359-7700 FOR ANY QUESTION REGARDING ELECTRONIC ADDENDA.


SEQUENCE OF OPERATIONS

- ① REPAIR OF FAILED AREAS AS DIRECTED
- ② FINE MILLING
- ③ PLACEMENT OF TEMPORARY STRIPE.
- ④ PRE-LEVELING AS DIRECTED
- ⑤ PLACEMENT OF SURFACE COURSE
- ⑥ PLACEMENT OF TEMPORARY STRIPE.
- ⑦ PLACEMENT OF PERMANENT STRIPE.

DISTRICT 1

PS & E PLANS-DATE 7/11/2018		
FMS CON. # 107677/301000		
REVISIONS		
DATE	SHEET NO.	BY

REVISION	MISSISSIPPI DEPARTMENT OF TRANSPORTATION	
	DETAILED INDEX	
	PROJECT NO.: NH-0056-01(098)	
	COUNTY: WINSTON	
DATE	DESIGN TEAM	CHECKED



WORKING NUMBER
DI-1

SHEET NUMBER
2

FILENAME: HWY 25 N WINSTON CO. 2018.DWG

DATE

6/22/2018 07:07:11 HWY 25 N WINSTON CO. 2018.DWG MISSISSIPPI DEPARTMENT OF TRANSPORTATION